



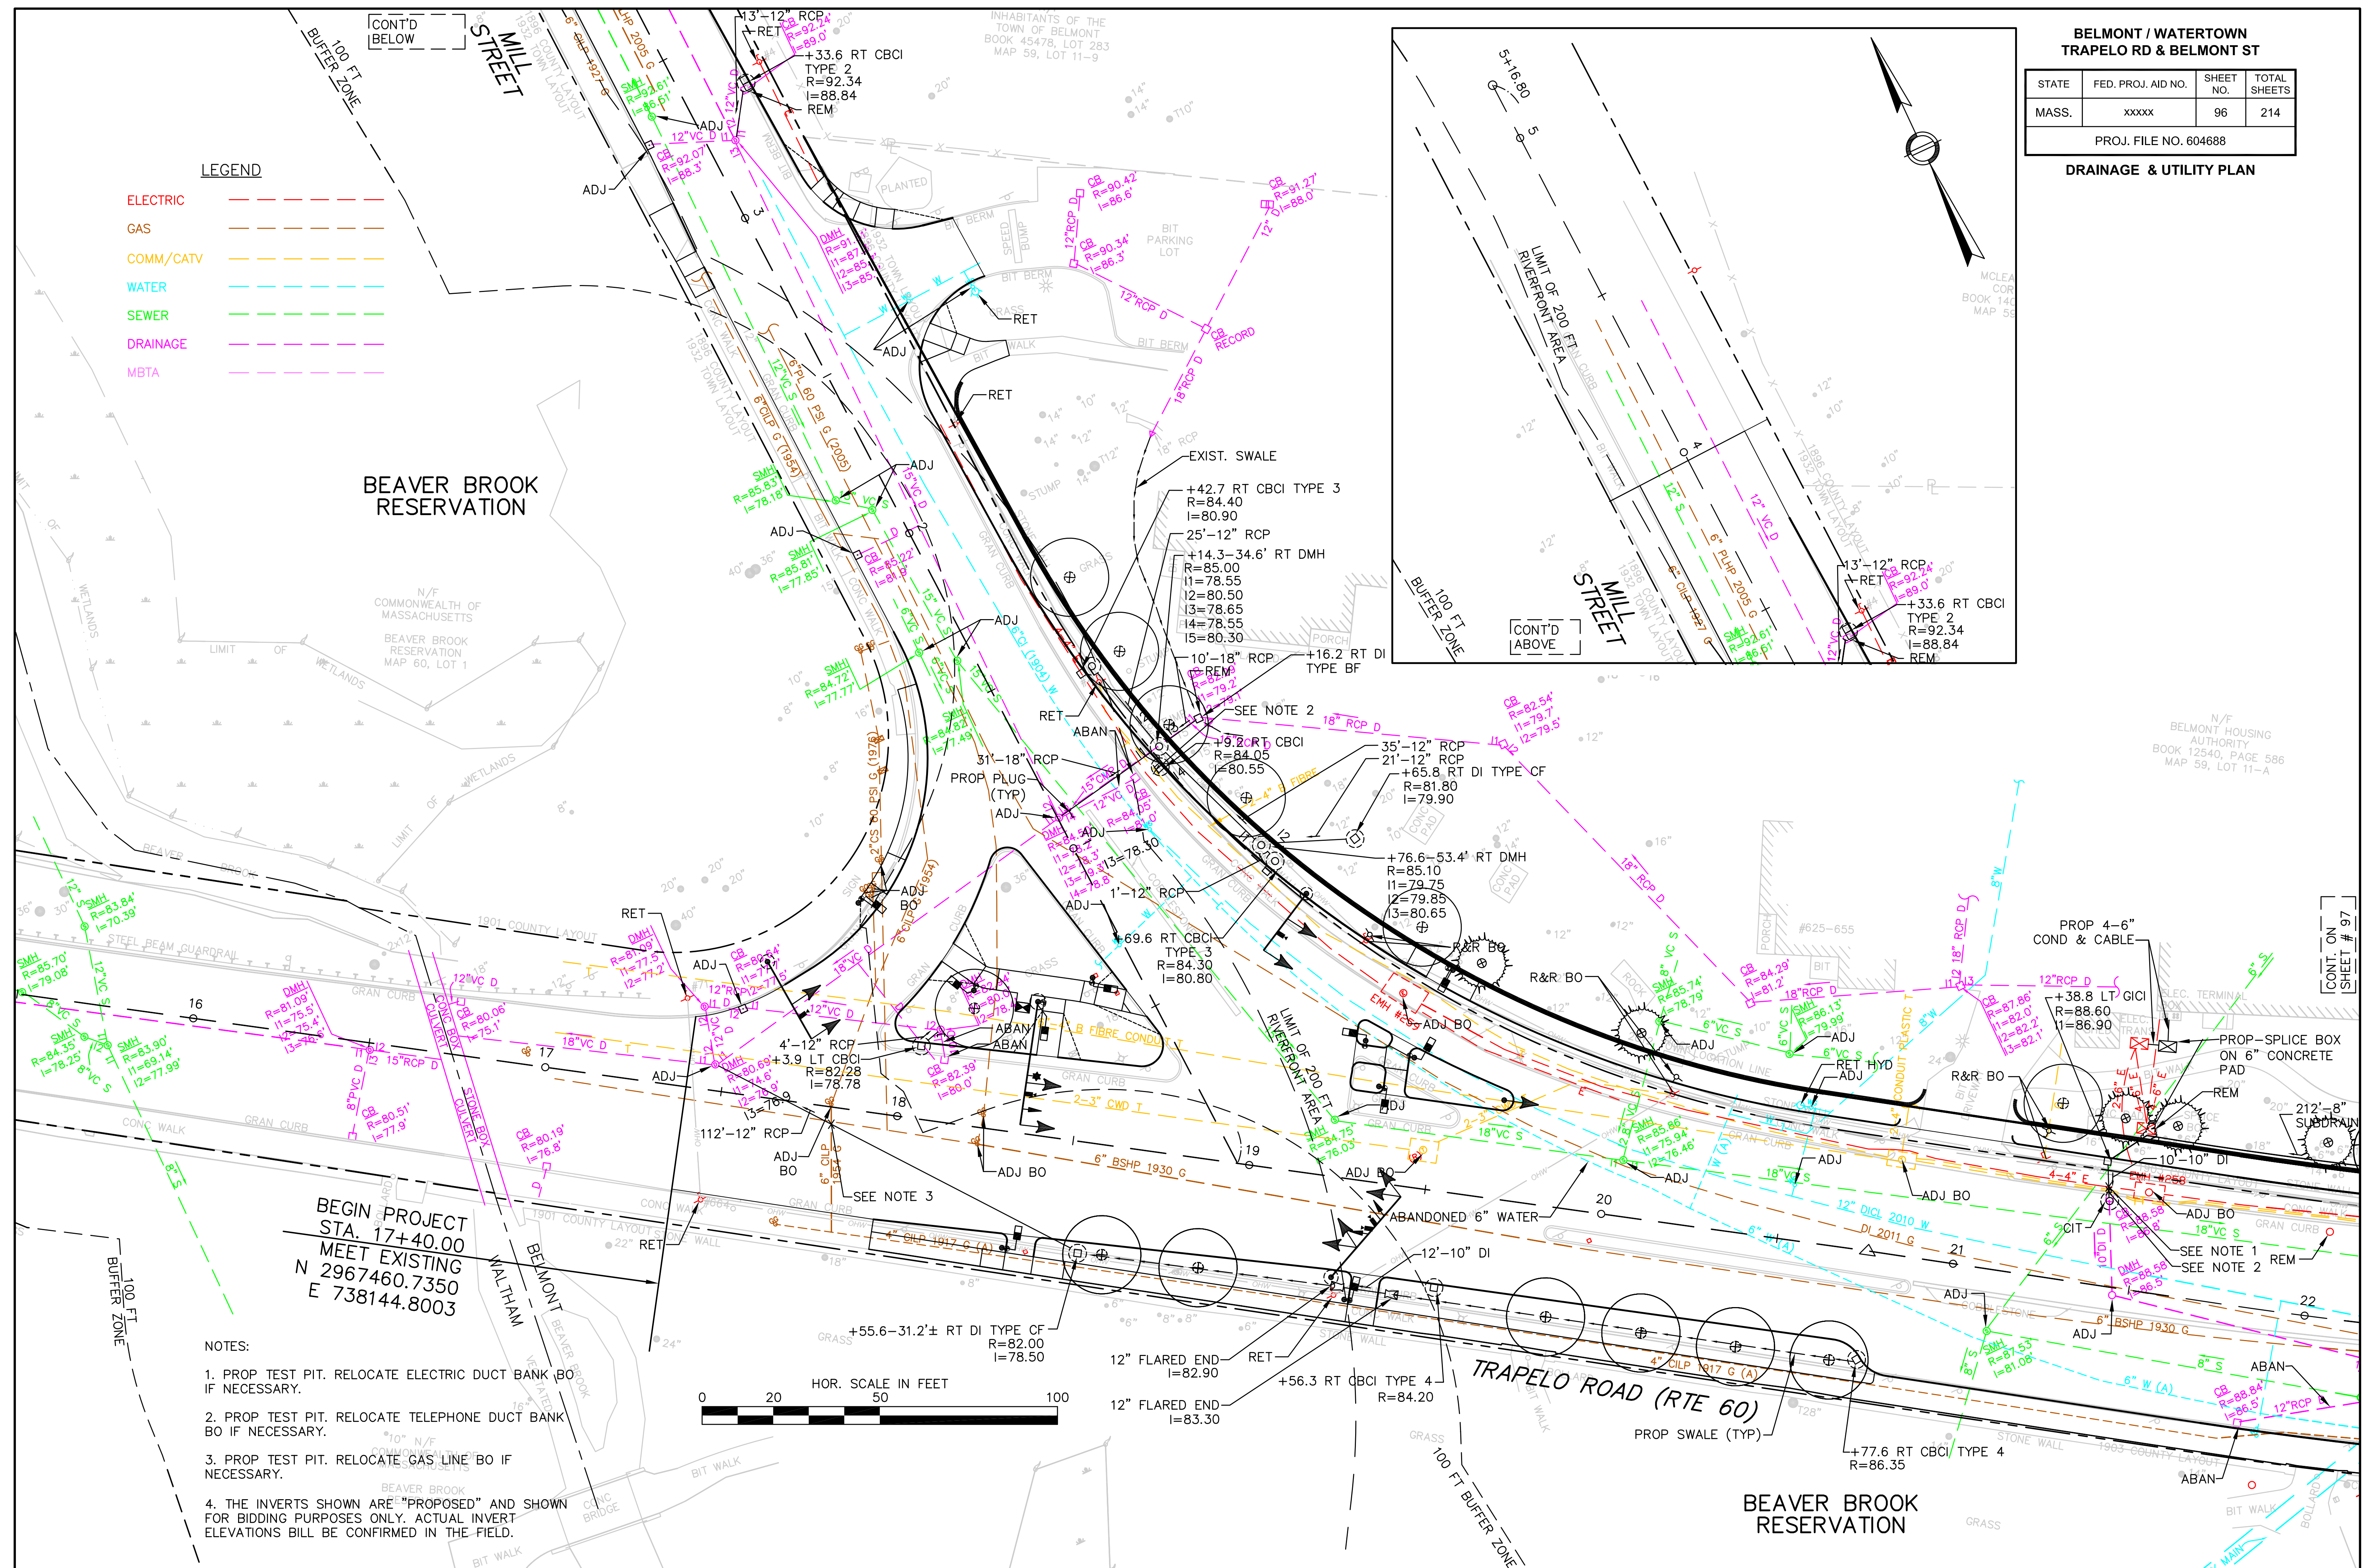

STATE	FED. PROJ. AID NO.	SHEET NO.	TOTAL SHEETS
MASS.	xxxxx	97	214



DRAINAGE & UTILITY PLAN

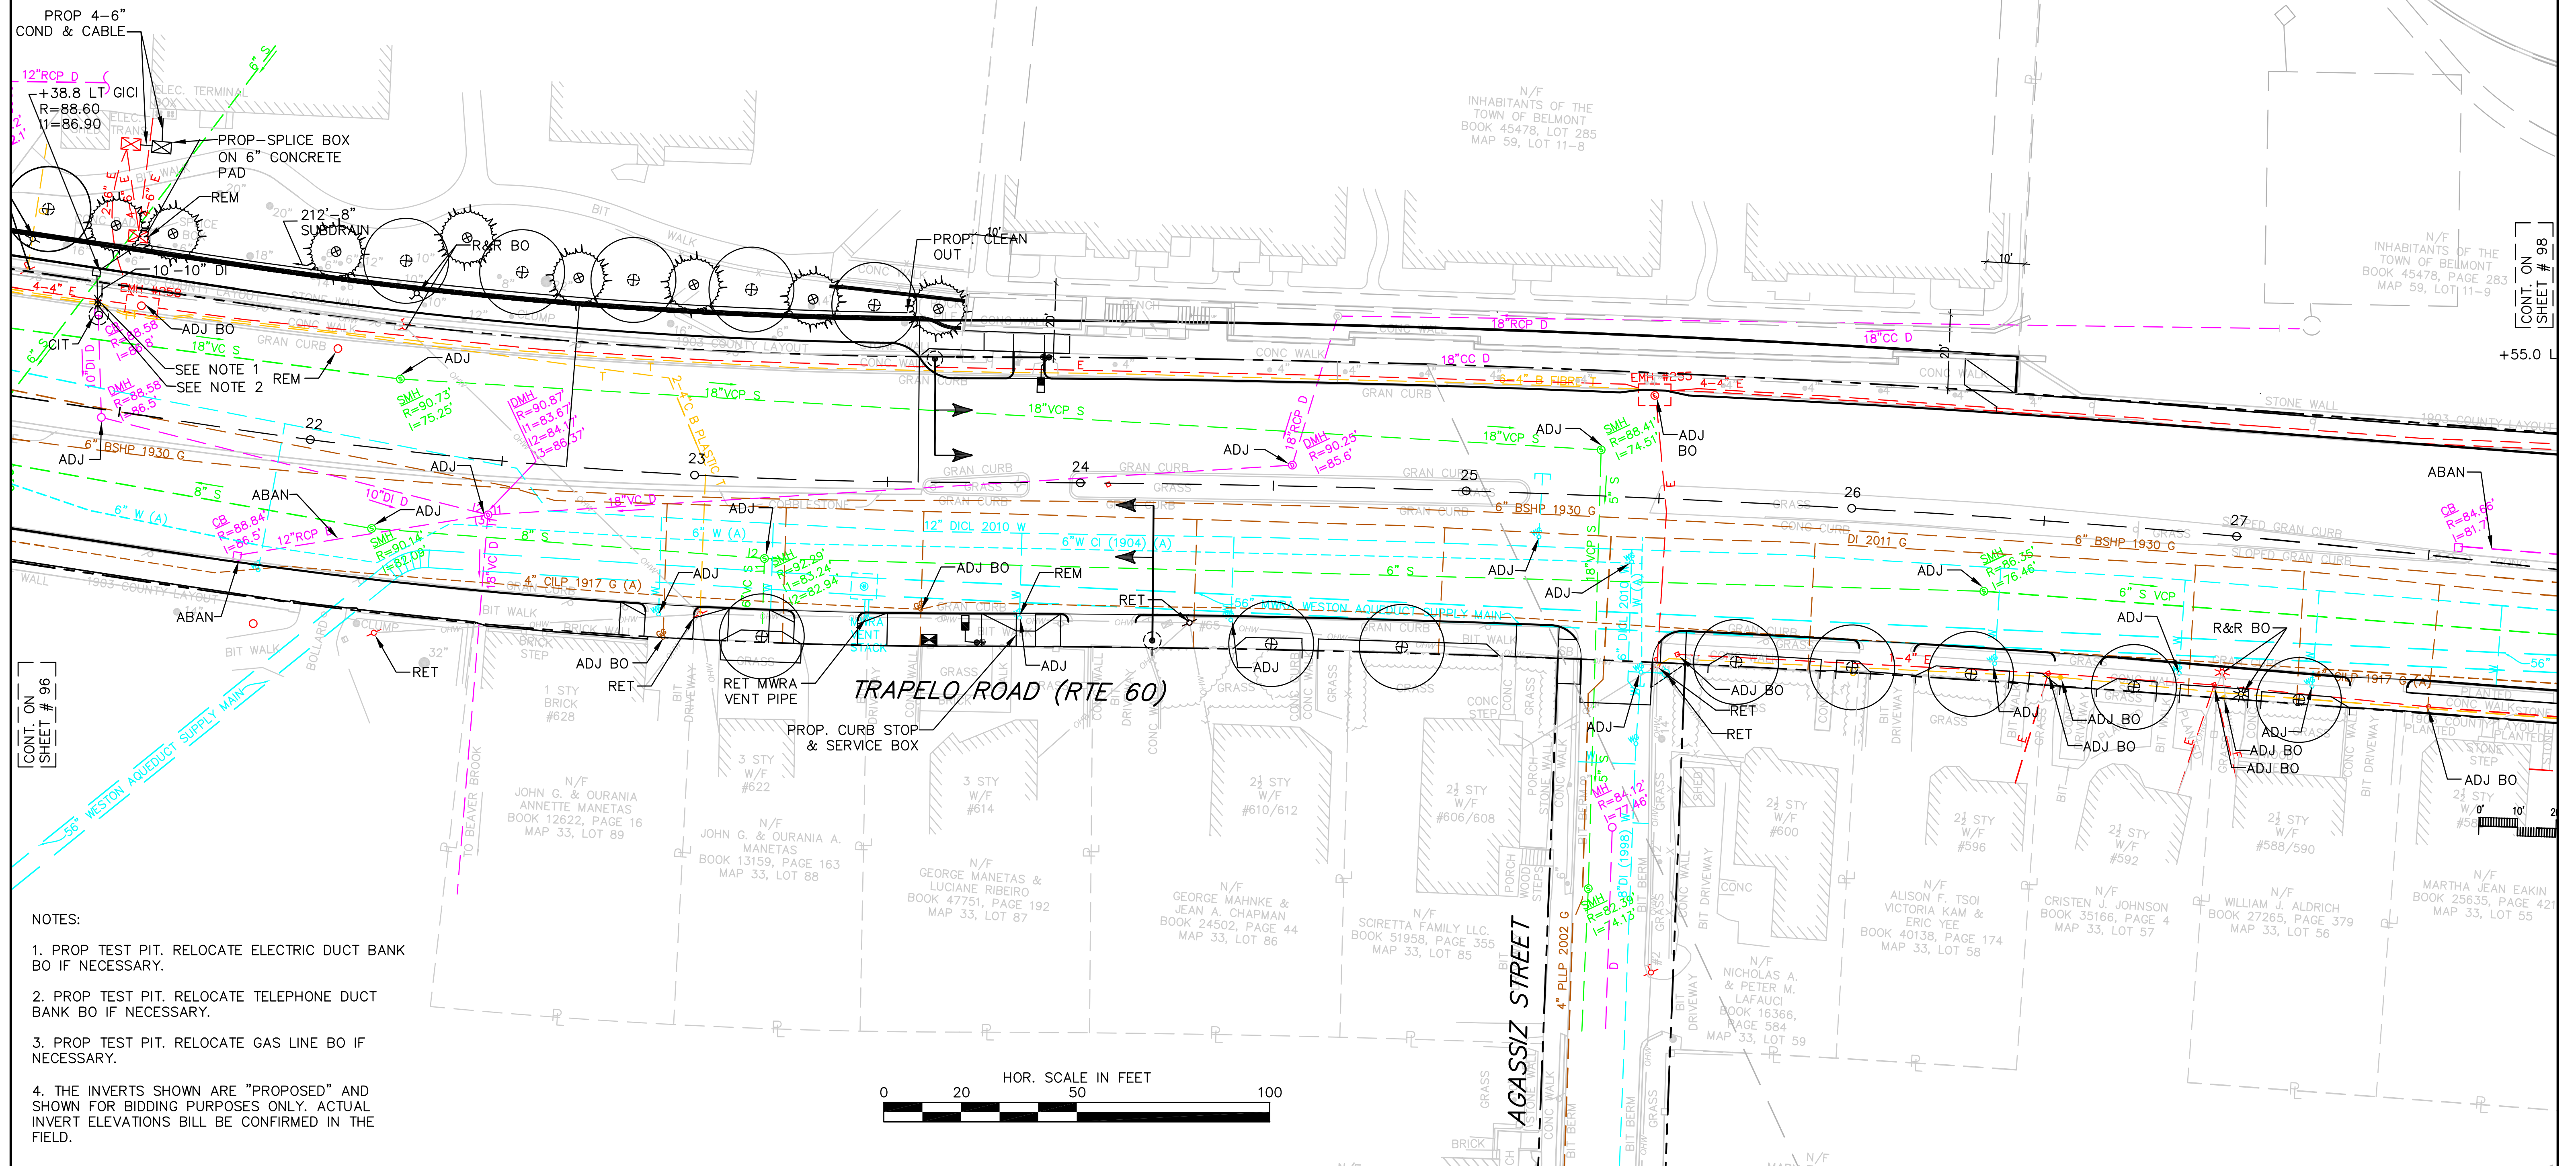

BELMONT / WATERTOWN
TRAPELO RD & BELMONT ST


STATE	FED. PROJ. AID NO.	SHEET NO.	TOTAL SHEETS
MASS.	xxxxx	98	214
PROJ. FILE NO. 604688			

DRAINAGE & UTILITY PLAN

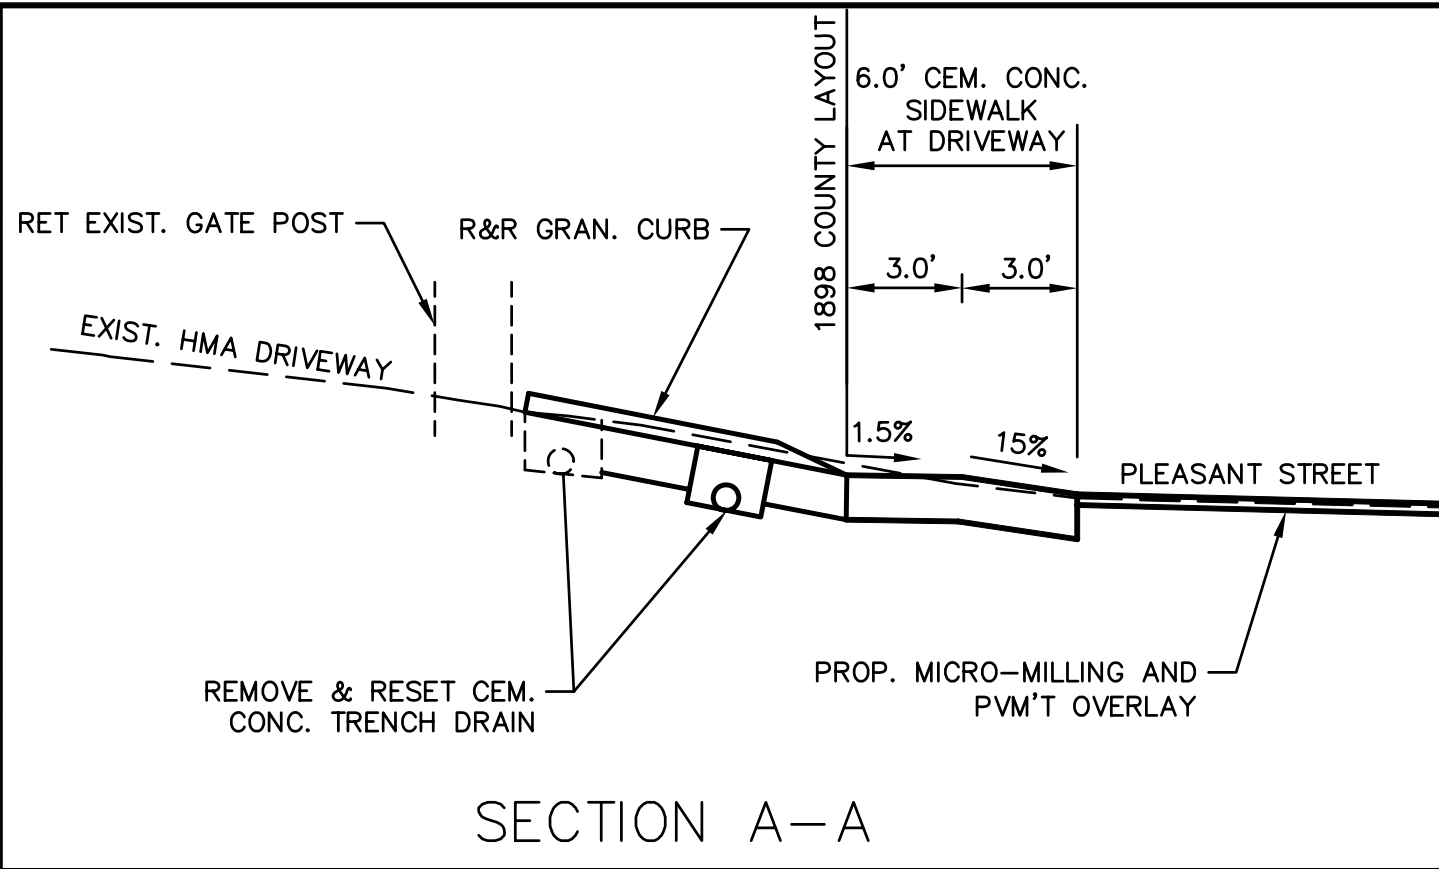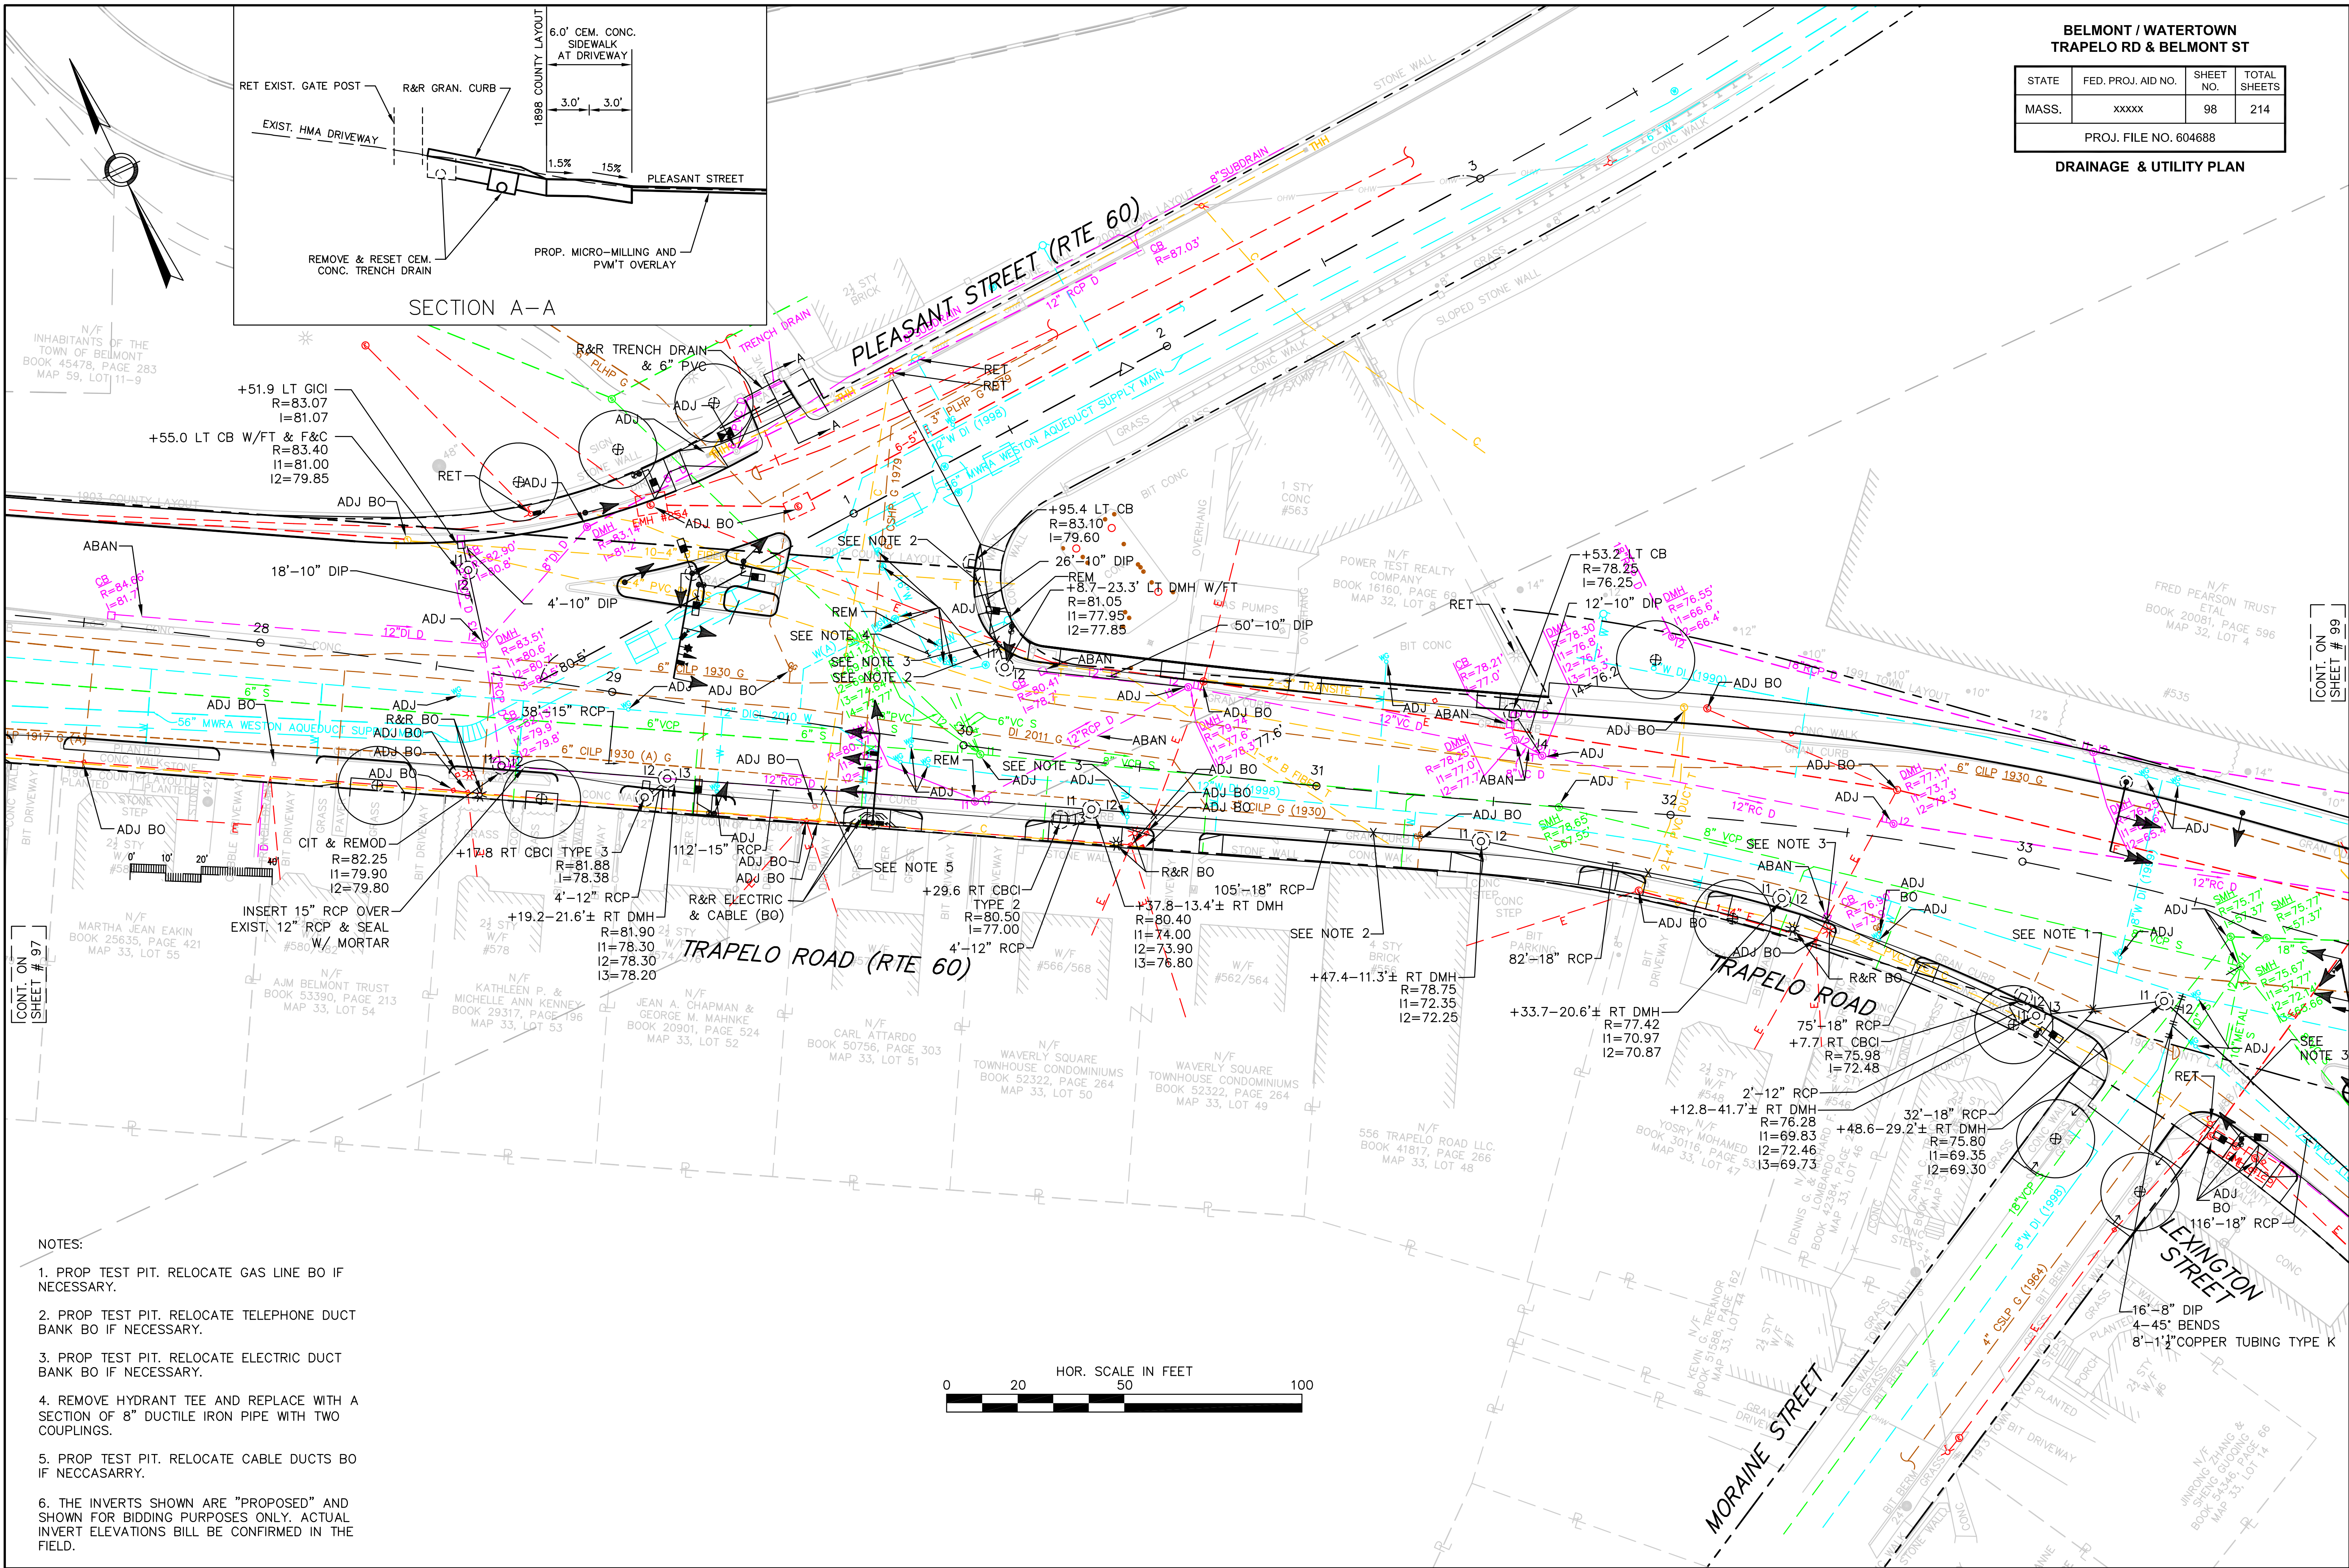

NOTES:


1. PROP TEST PIT. RELOCATE GAS LINE BO IF NECESSARY.
2. PROP TEST PIT. RELOCATE TELEPHONE DUCT BANK BO IF NECESSARY.
3. PROP TEST PIT. RELOCATE ELECTRIC DUCT BANK BO IF NECESSARY.
4. REMOVE HYDRANT TEE AND REPLACE WITH A SECTION OF 8" DUCTILE IRON PIPE WITH TWO COUPLINGS.
5. PROP TEST PIT. RELOCATE CABLE DUCTS BO IF NECESSARY.
6. THE INVERTS SHOWN ARE "PROPOSED" AND SHOWN FOR BIDDING PURPOSES ONLY. ACTUAL INVERT ELEVATIONS WILL BE CONFIRMED IN THE FIELD.

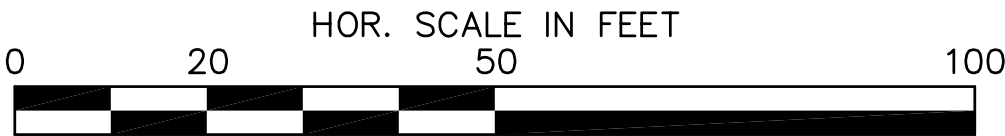

**BELMONT / WATERTOWN
TRAPELO RD & BELMONT ST**

STATE	FED. PROJ. AID NO.	SHEET NO.	TOTAL SHEETS
MASS.	XXXXX	99	214
PROJ. FILE NO. 604688			

DRAINAGE & UTILITY PLAN

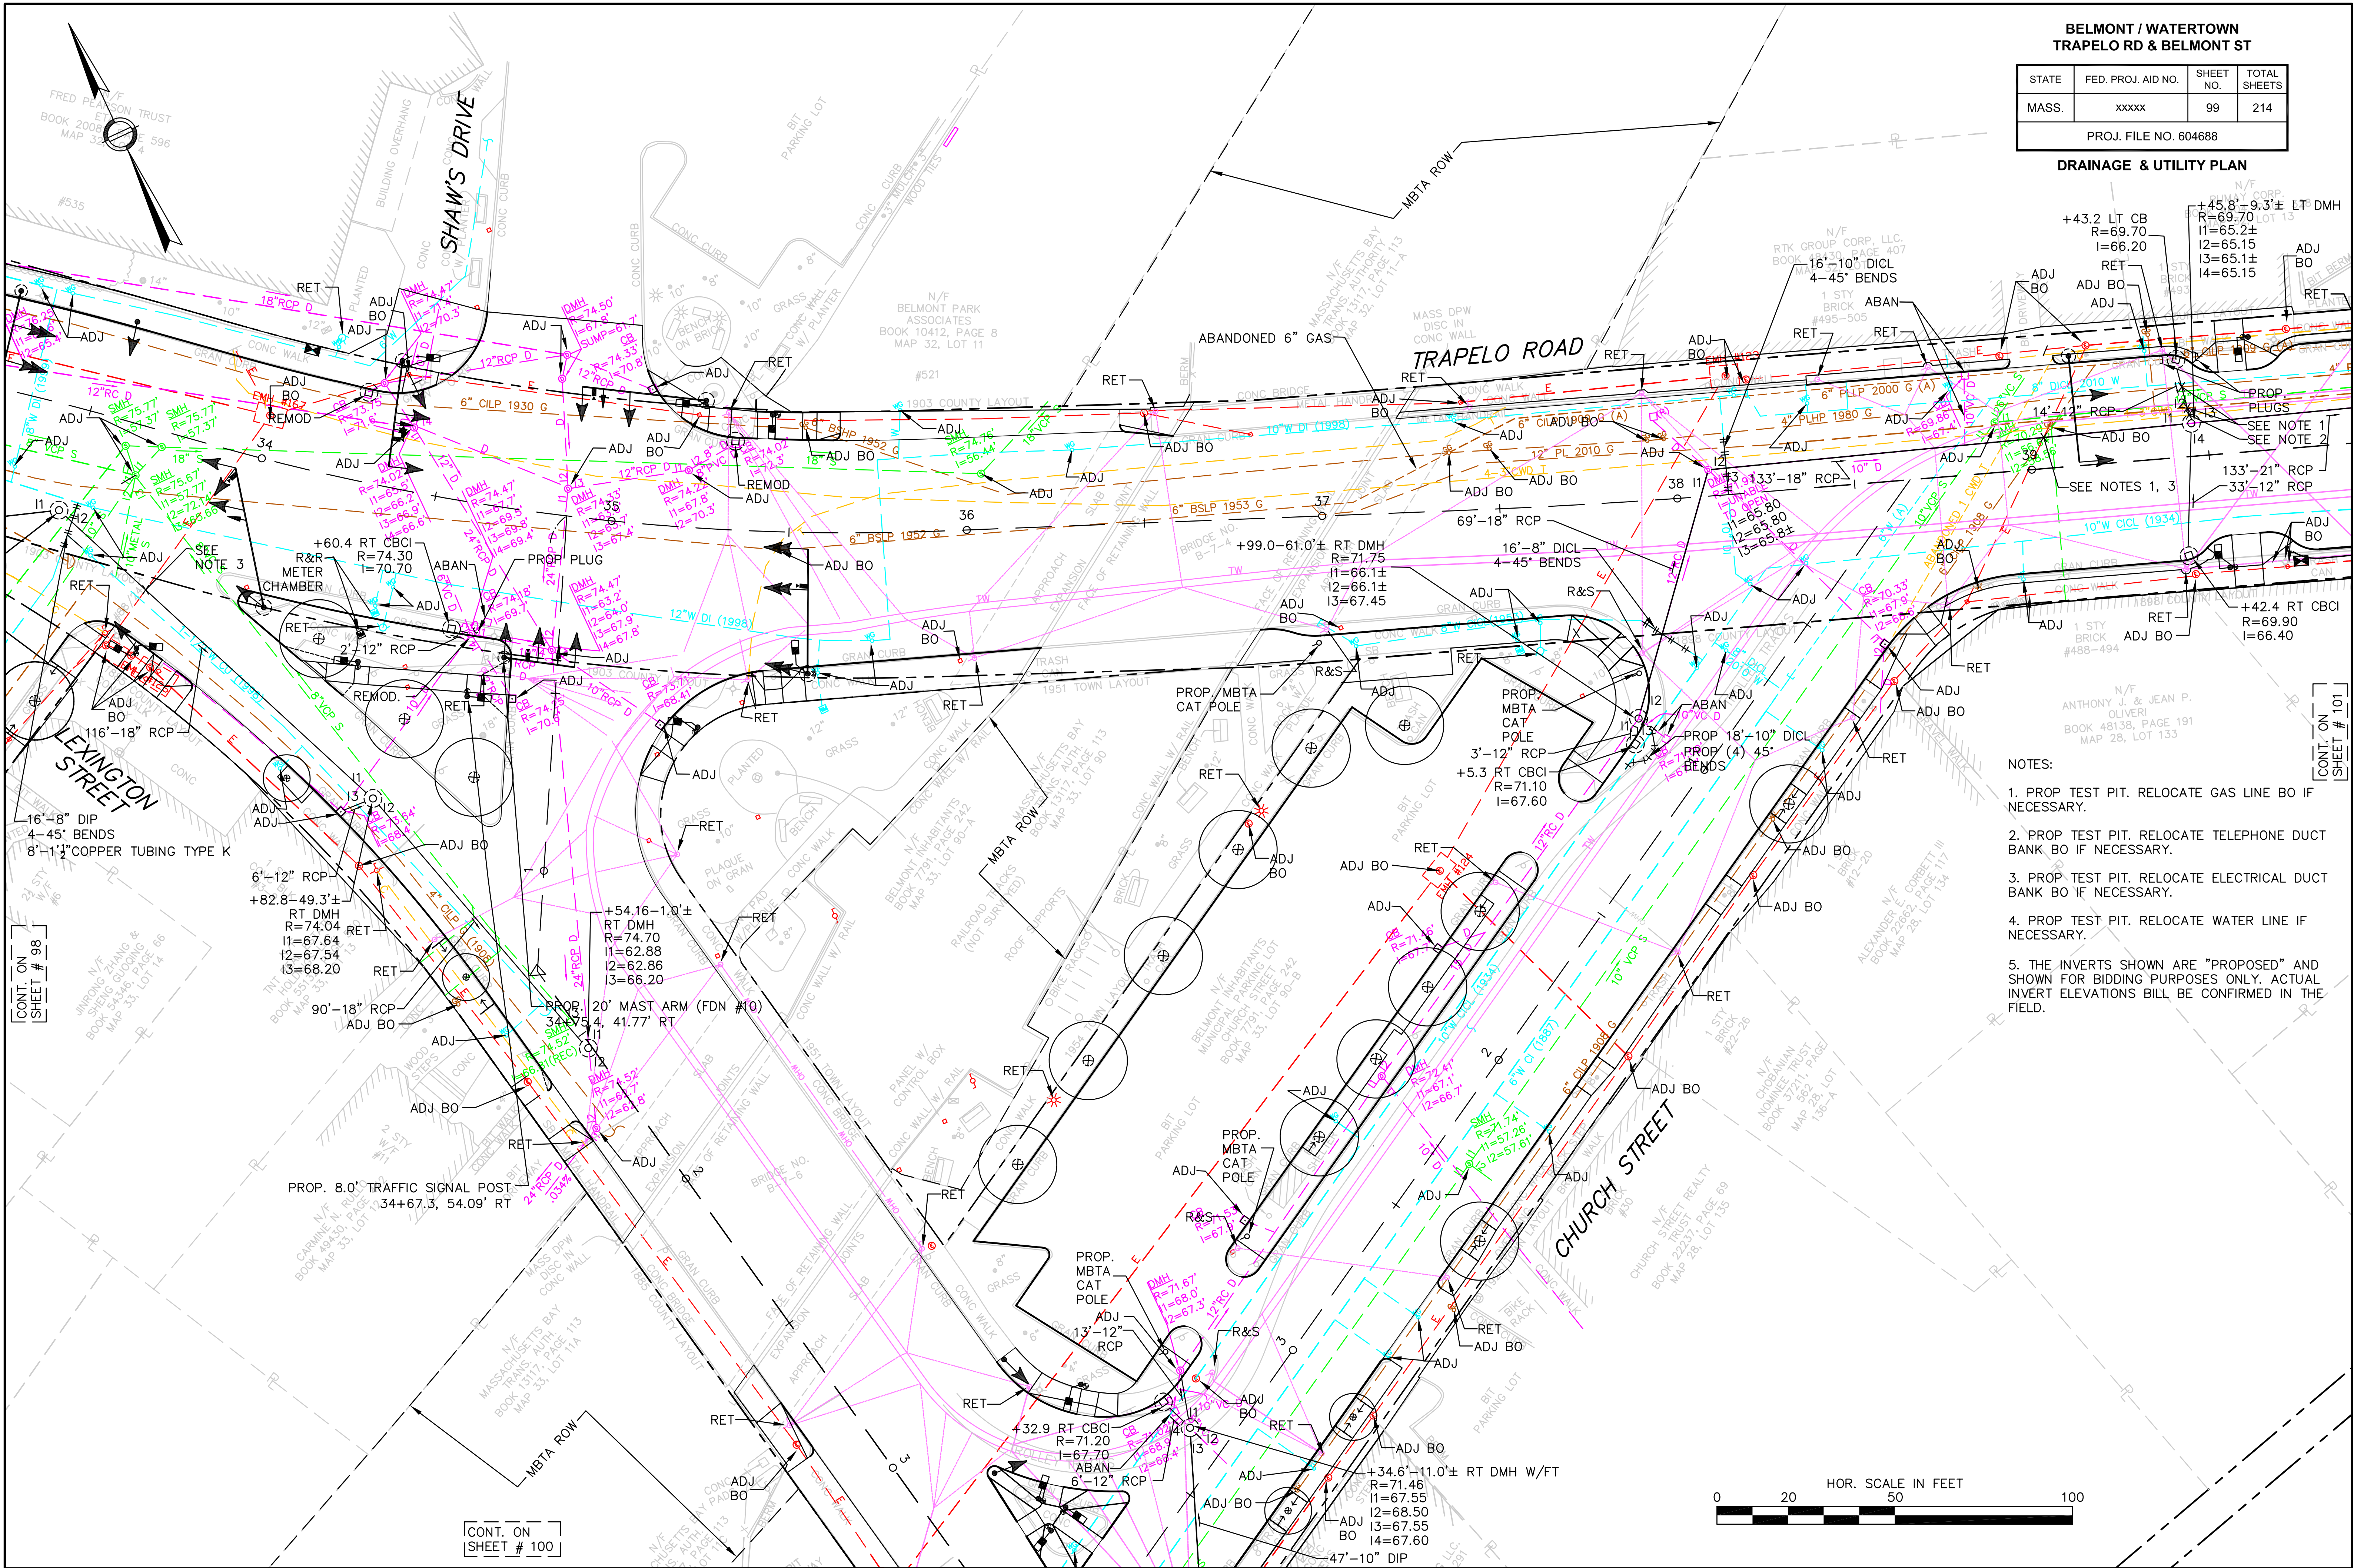

- NOTES:
1. PROP TEST PIT. RELOCATE GAS LINE BO IF NECESSARY.
 2. PROP TEST PIT. RELOCATE TELEPHONE DUCT BANK BO IF NECESSARY.
 3. PROP TEST PIT. RELOCATE ELECTRICAL DUCT BANK BO IF NECESSARY.
 4. PROP TEST PIT. RELOCATE WATER LINE IF NECESSARY.
 5. THE INVERTS SHOWN ARE "PROPOSED" AND SHOWN FOR BIDDING PURPOSES ONLY. ACTUAL INVERT ELEVATIONS WILL BE CONFIRMED IN THE FIELD.

CONT. ON
SHEET # 98

CONT. ON
SHEET # 100

CONT. ON
SHEET # 101

BELMONT / WATERTOWN
TRAPELO RD & BELMONT ST

STATE	FED. PROJ. AID NO.	SHEET NO.	TOTAL SHEETS
MASS.	xxxxx	100	214



PROJ. FILE NO. 604688

DRAINAGE & UTILITY PLAN

CONT. ON
SHEET # 99

NOTES:


1. THE INVERTS SHOWN ARE "PROPOSED" AND SHOWN FOR BIDDING PURPOSES ONLY. ACTUAL INVERT ELEVATIONS WILL BE CONFIRMED IN THE FIELD.

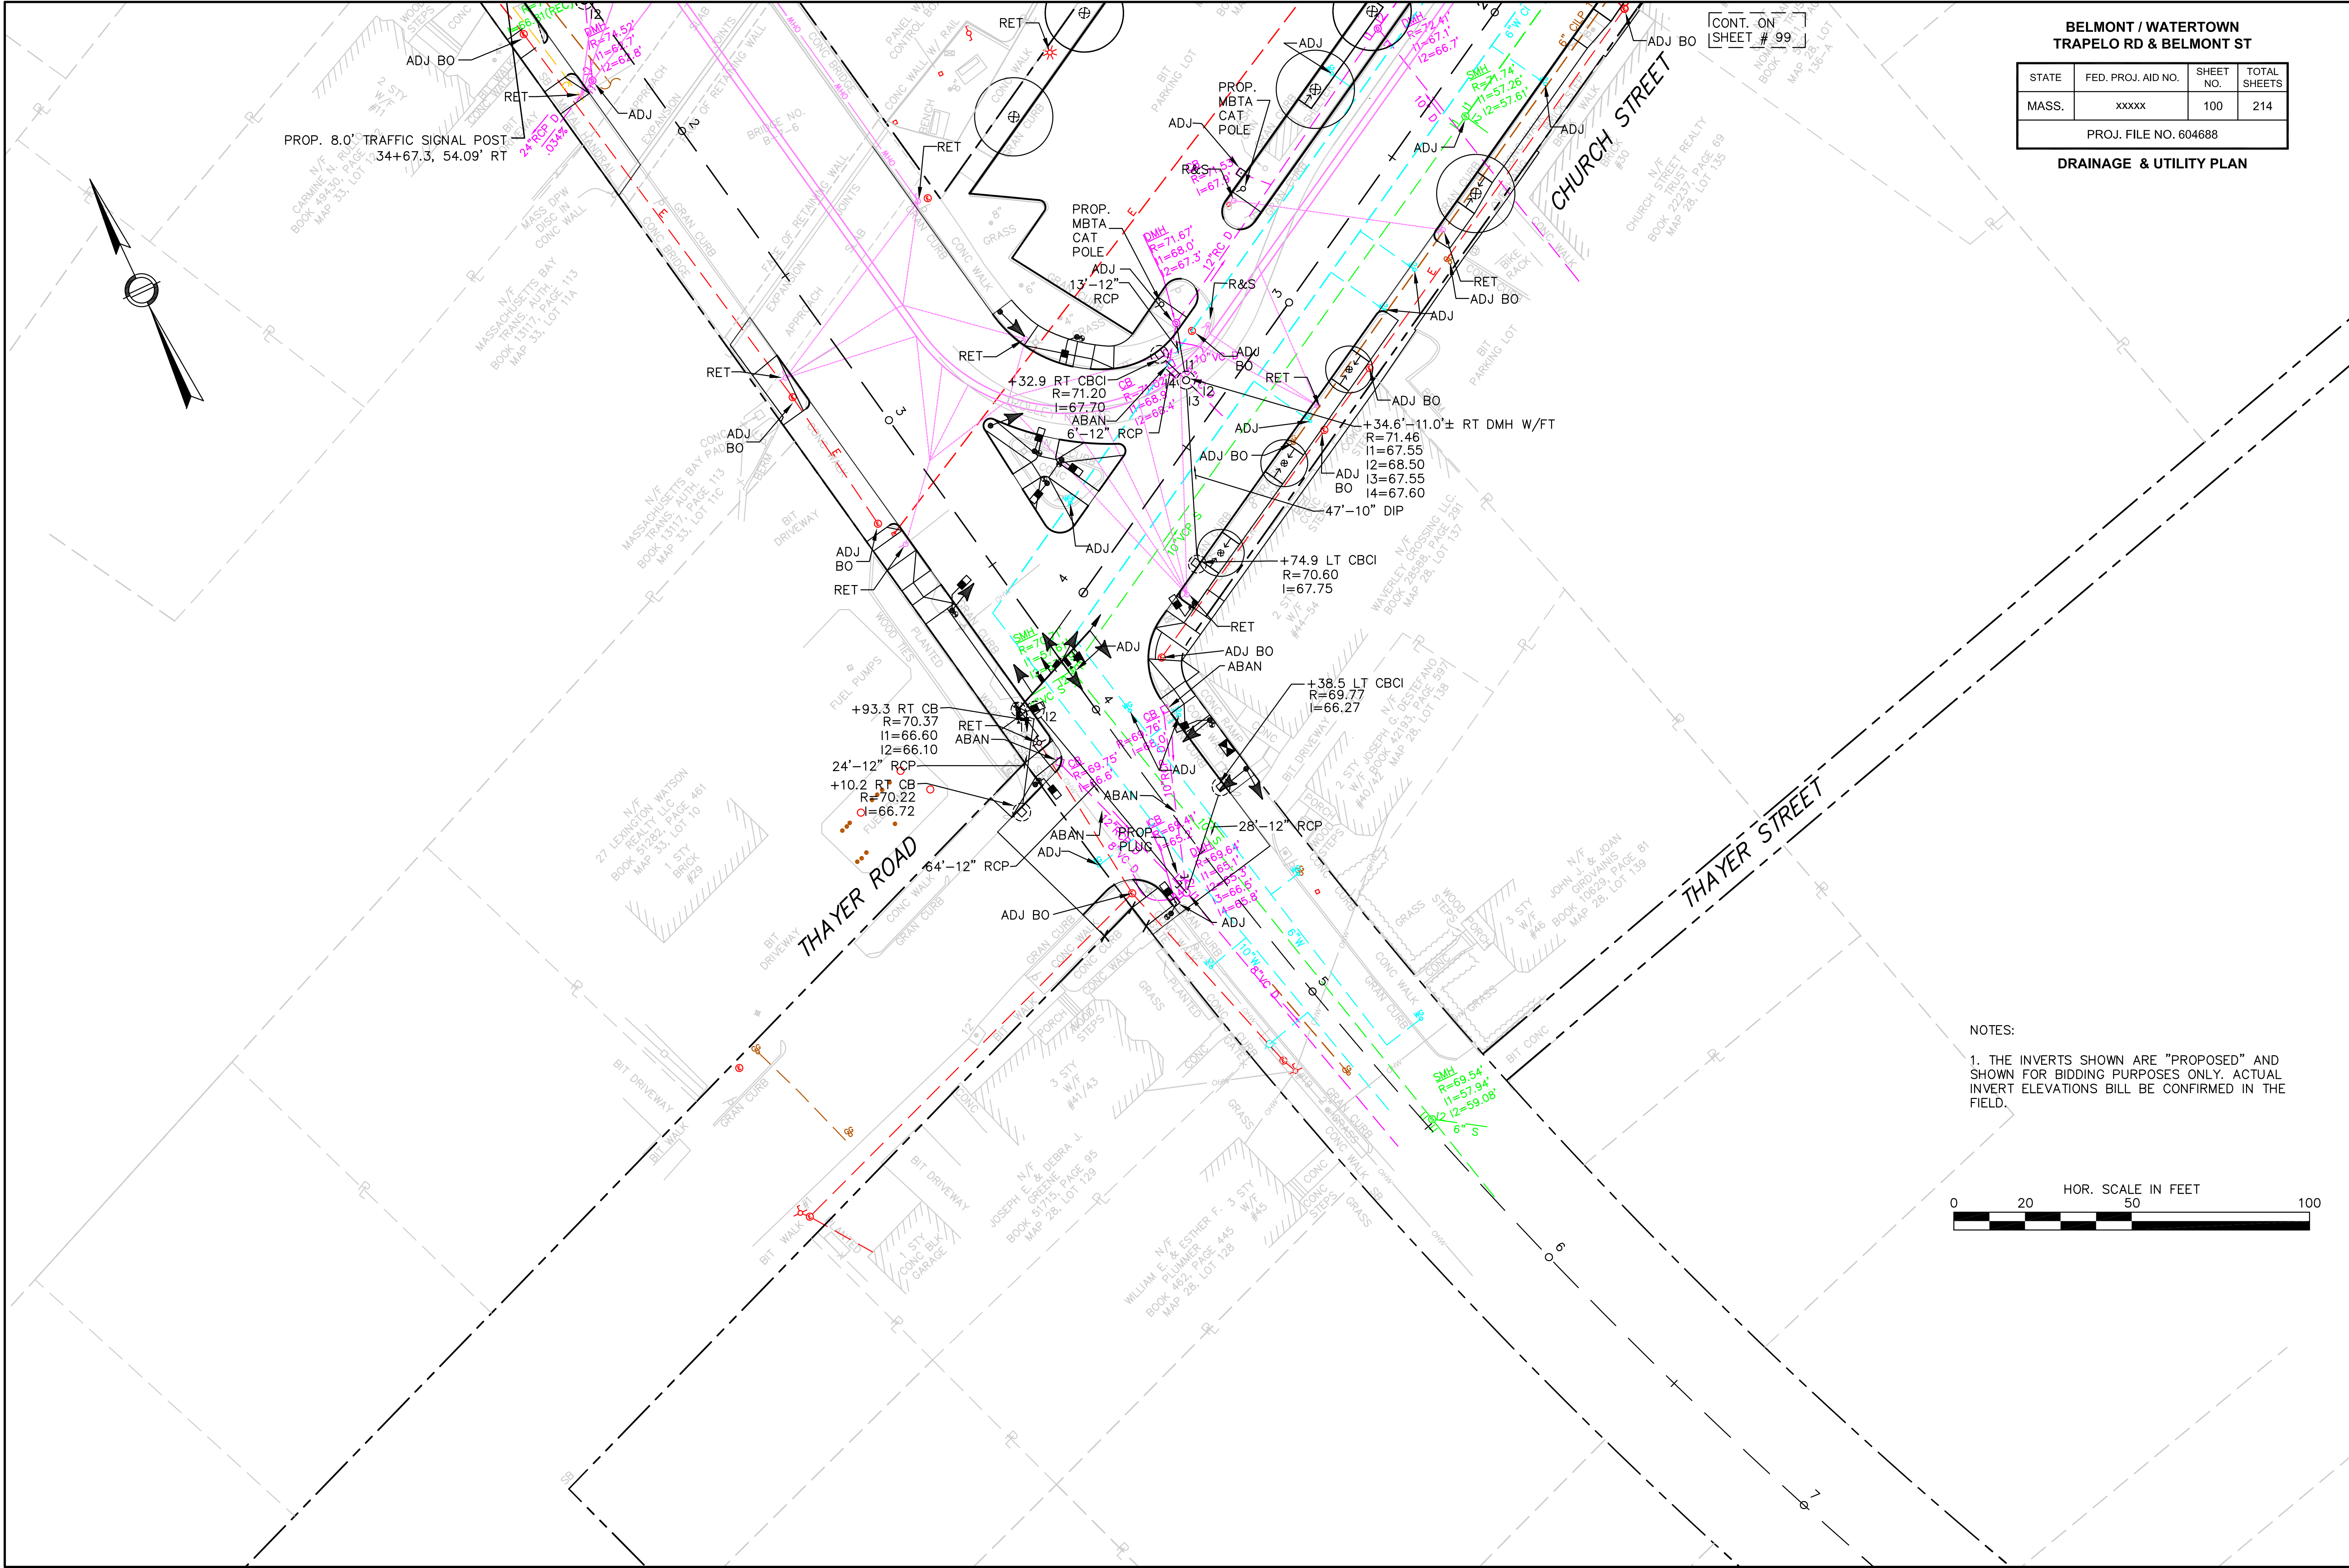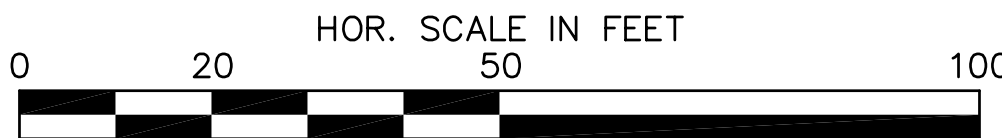

**BELMONT / WATERTOWN
TRAPELO RD & BELMONT ST**

STATE	FED. PROJ. AID NO.	SHEET NO.	TOTAL SHEETS
MASS.	xxxxxx	101	214
PROJ. FILE NO. 604688			


DRAINAGE & UTILITY PLAN

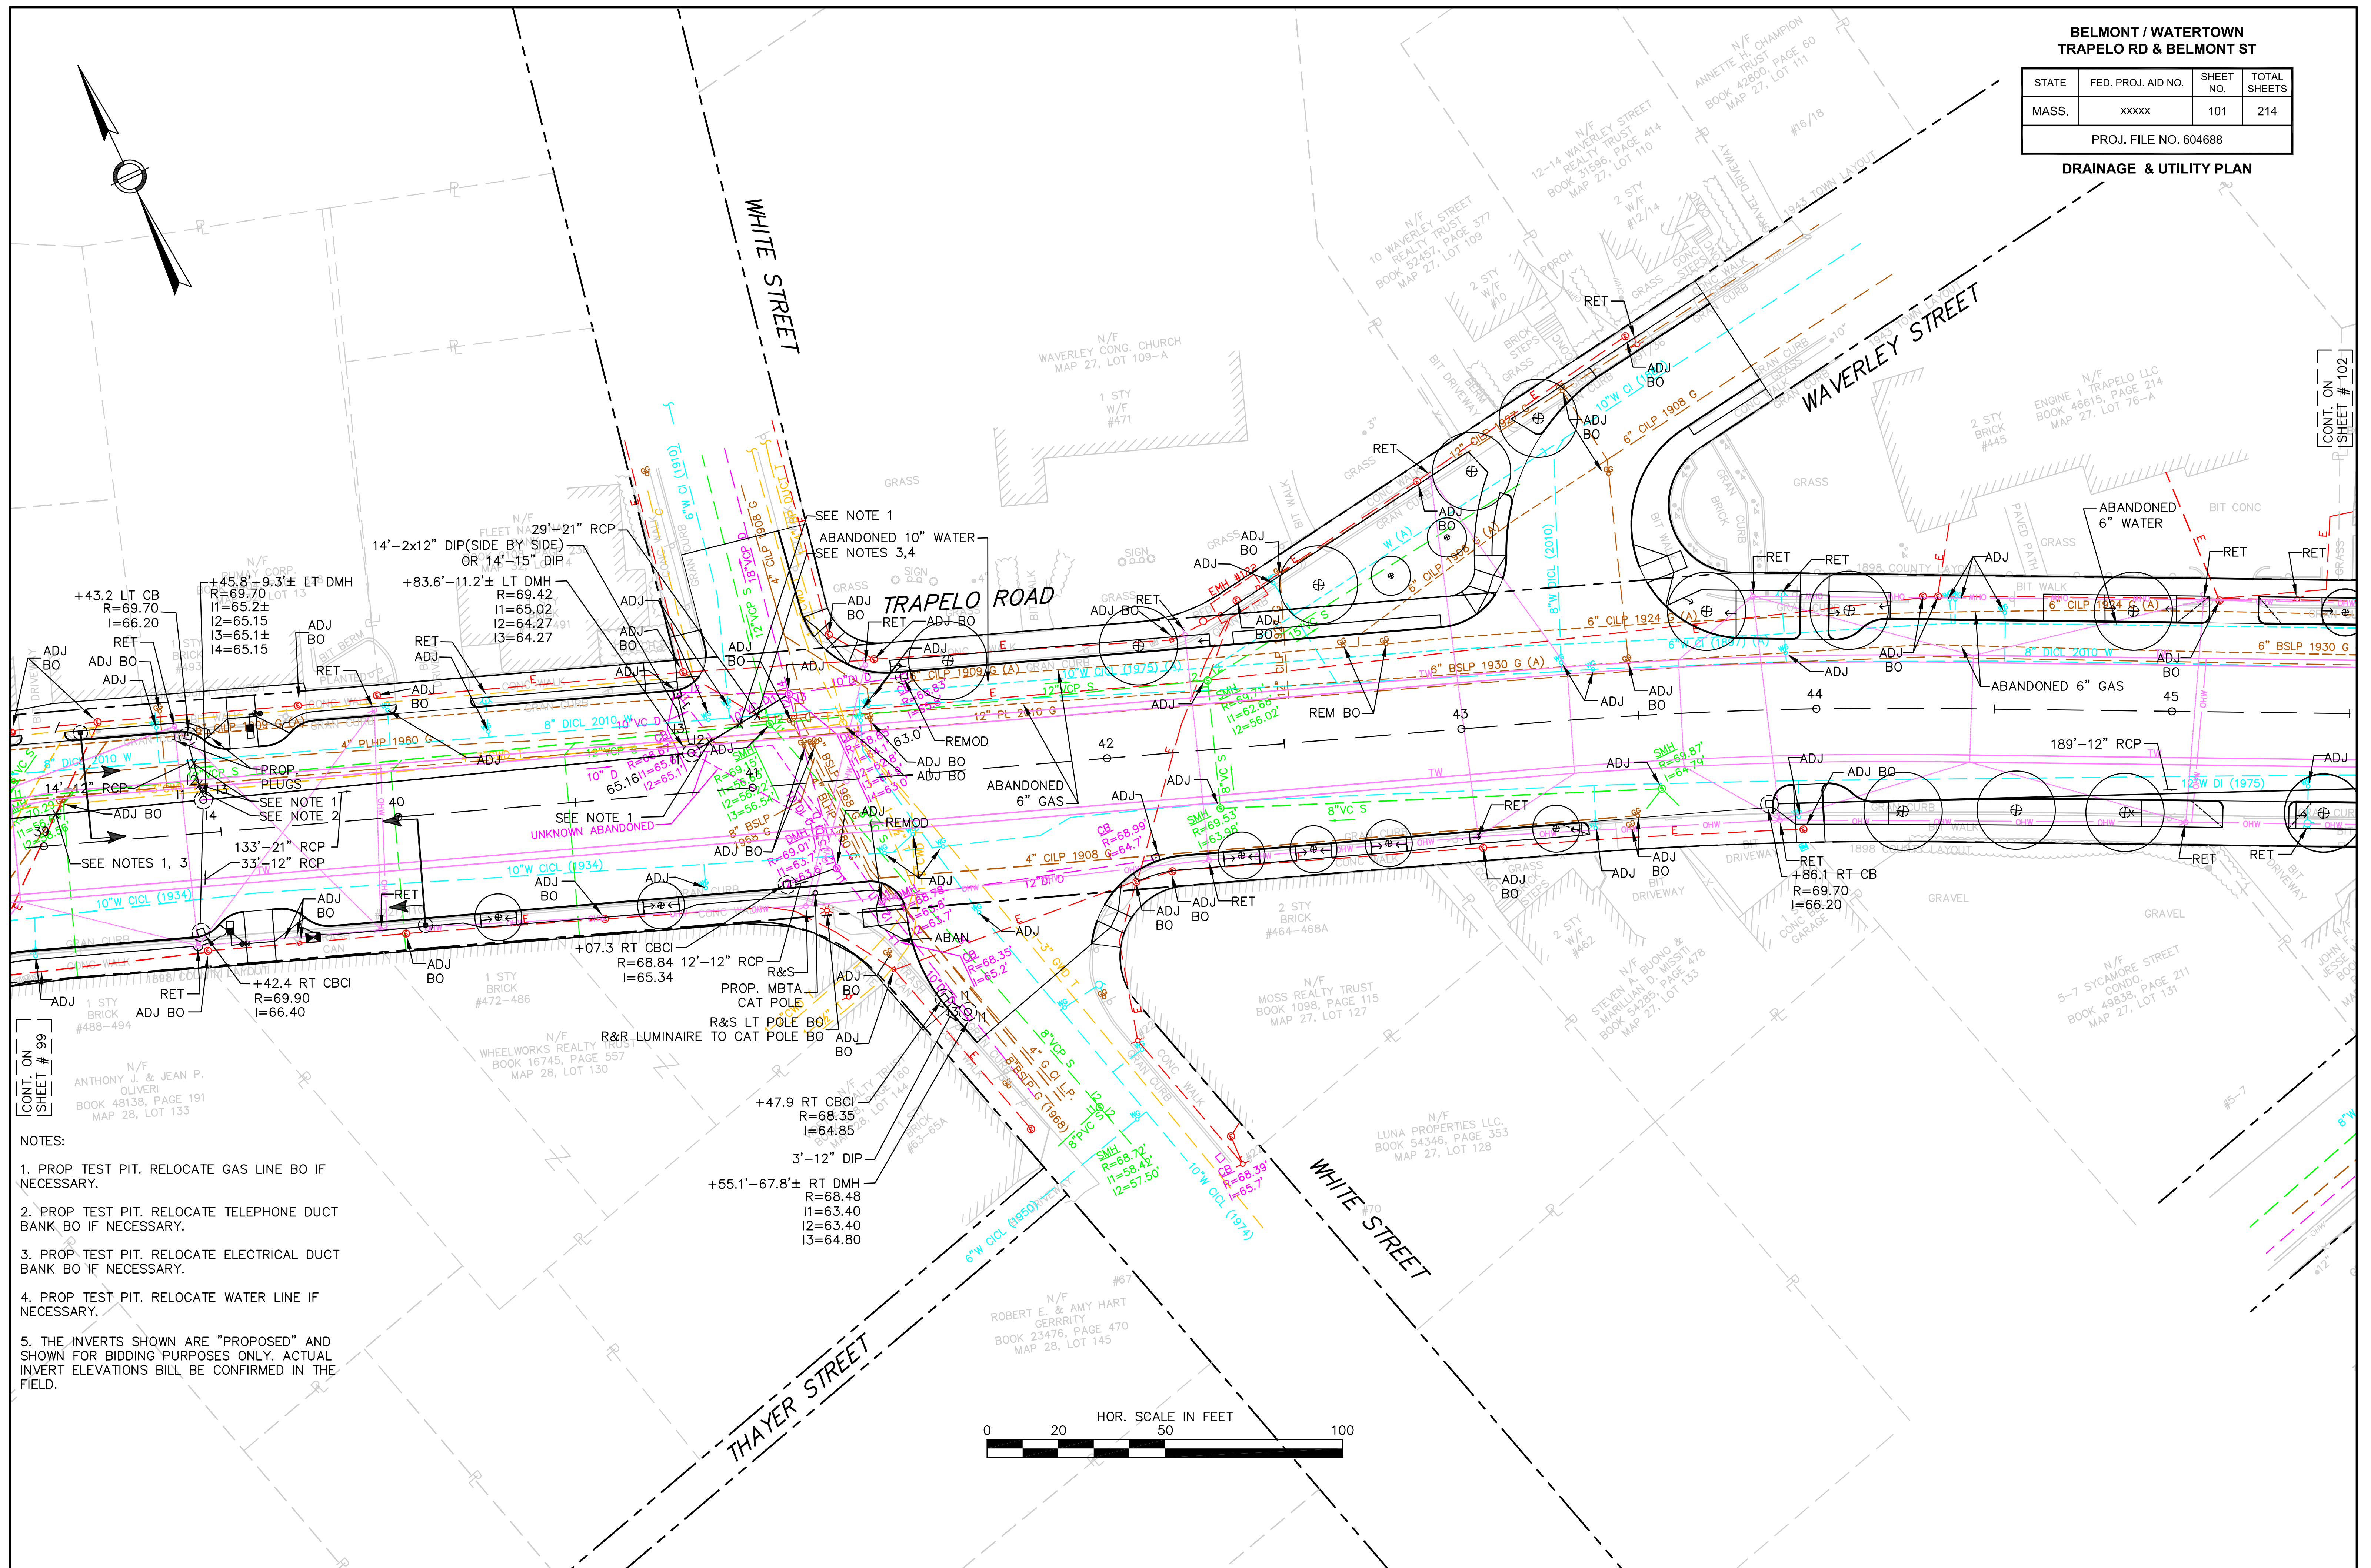

BELMONT / WATERTOWN
TRAPELO RD & BELMONT ST

STATE	FED. PROJ. AID NO.	SHEET NO.	TOTAL SHEETS
MASS.	xxxxx	102	214
PROJ. FILE NO. 604688			

DRAINAGE & UTILITY PLAN

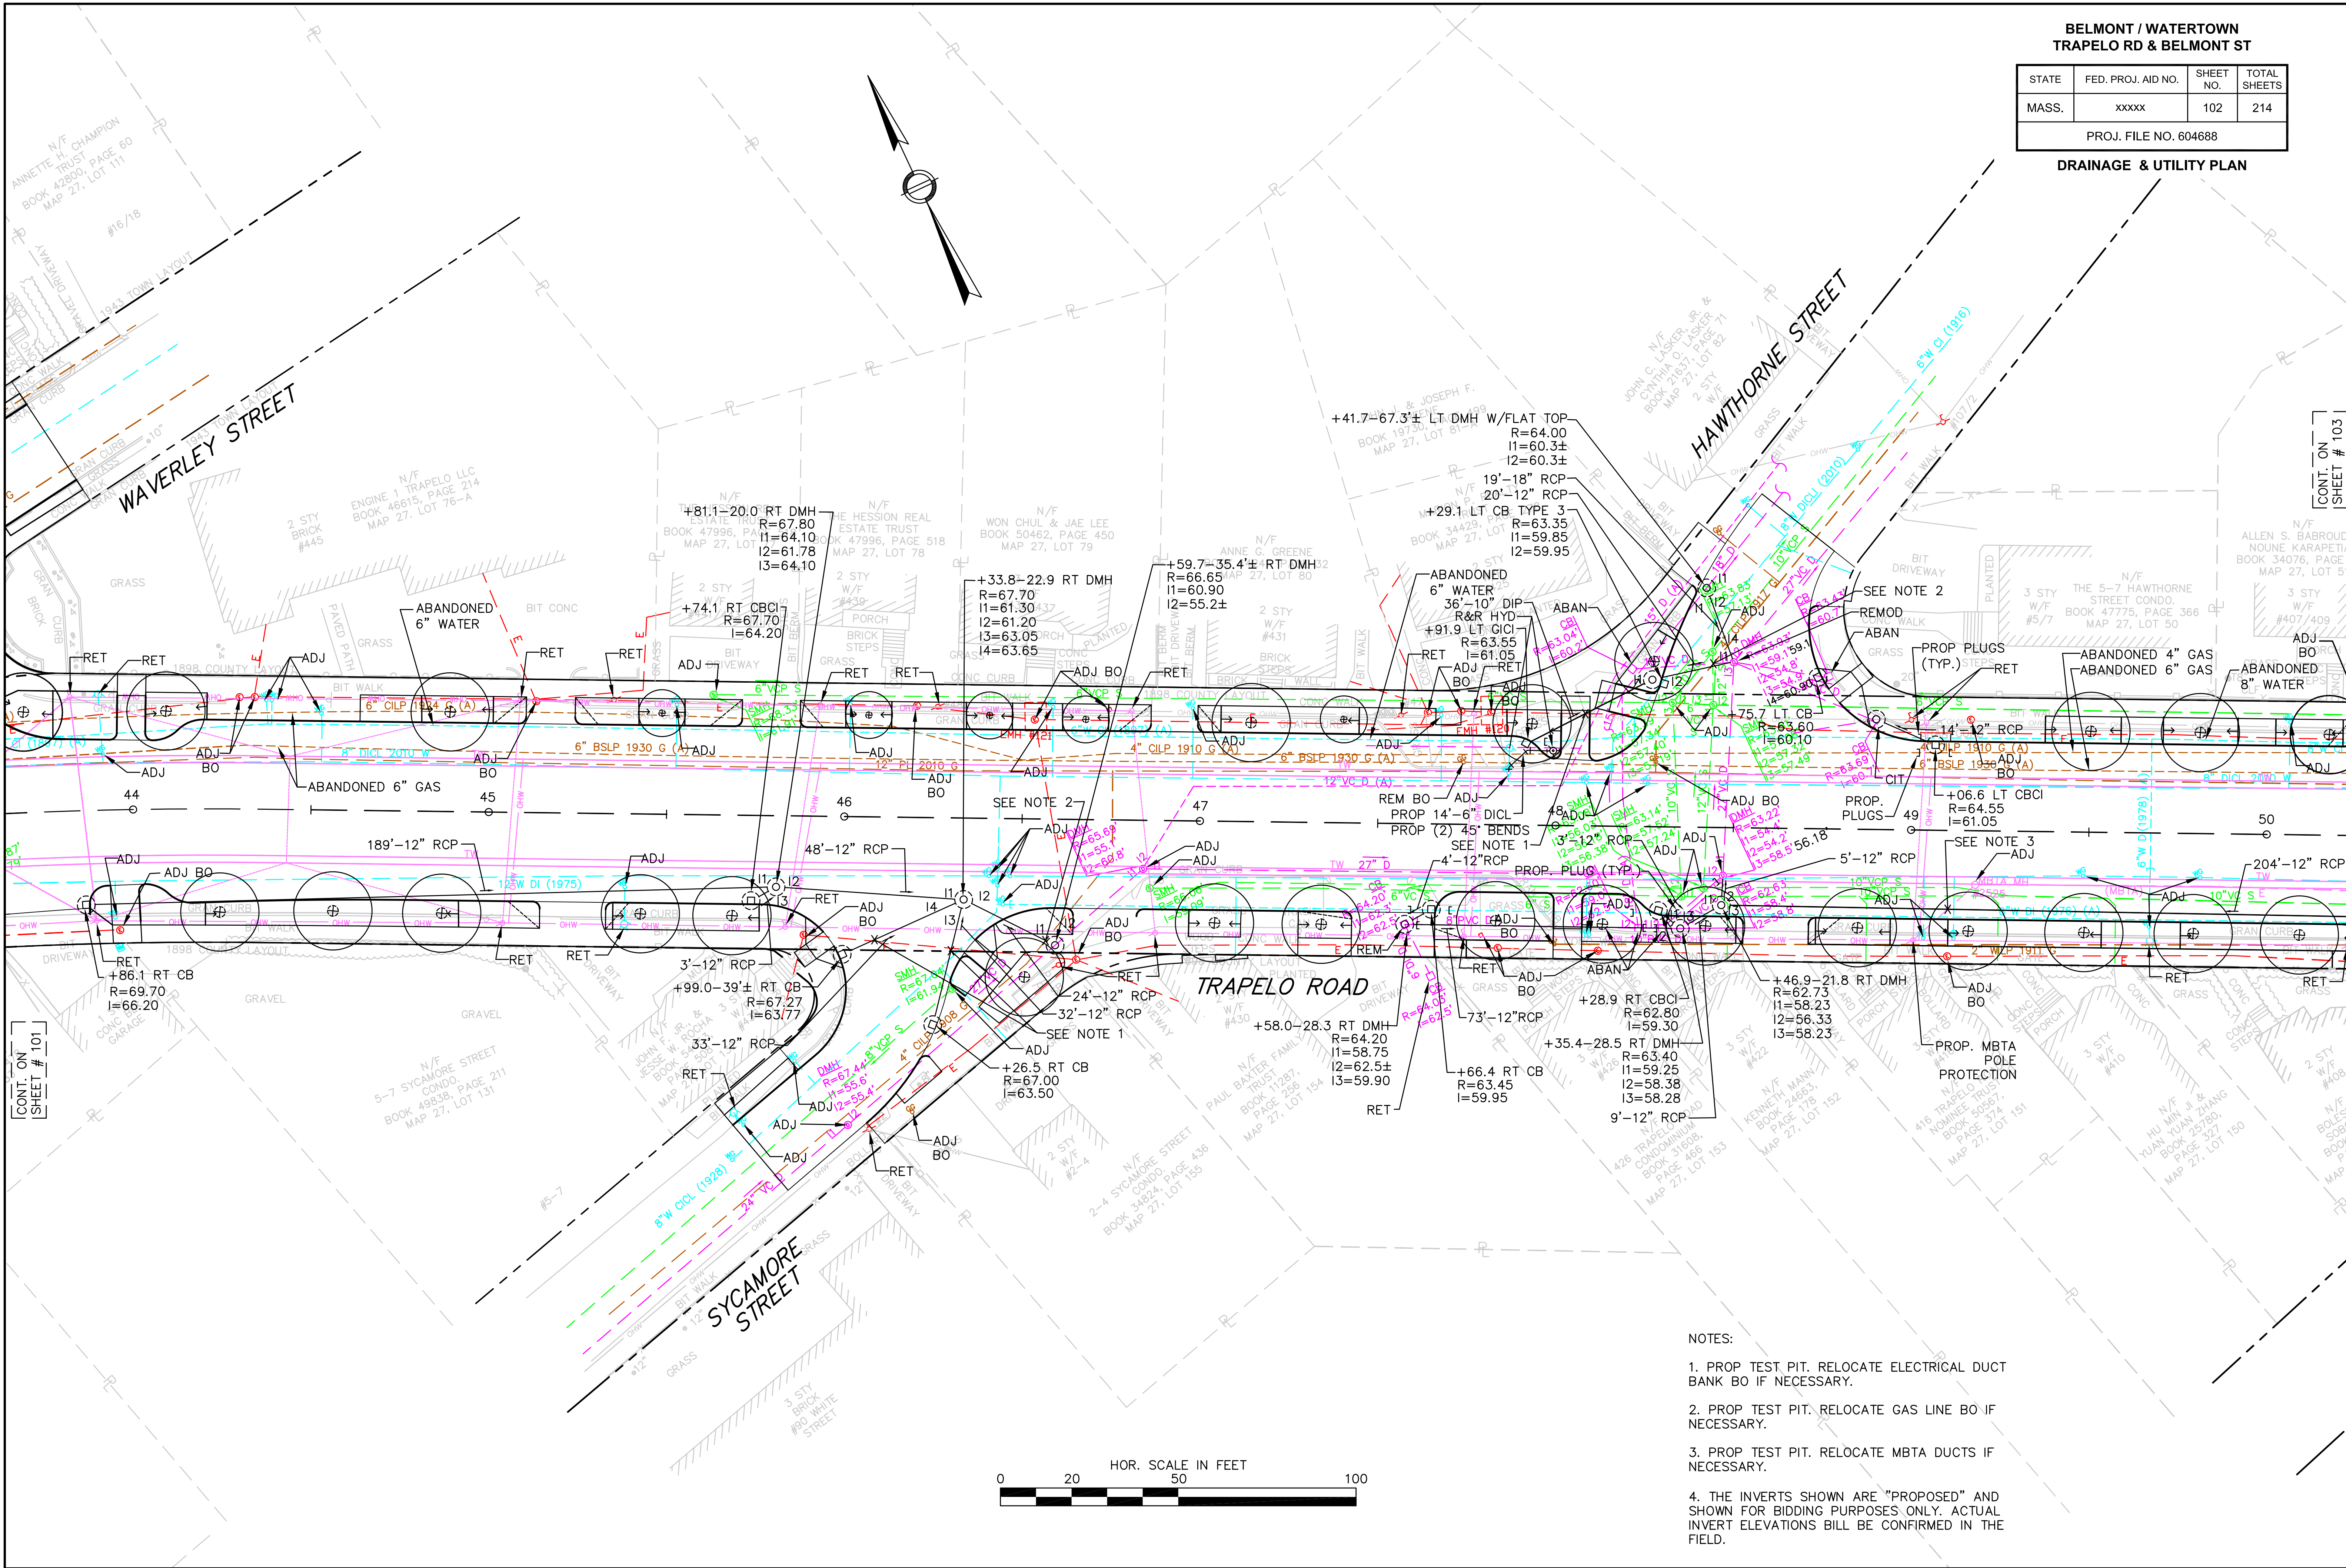

NOTES:


1. PROP TEST PIT. RELOCATE ELECTRICAL DUCT BANK BO IF NECESSARY.
2. PROP TEST PIT. RELOCATE GAS LINE BO IF NECESSARY.
3. PROP TEST PIT. RELOCATE MBTA DUCTS IF NECESSARY.
4. THE INVERTS SHOWN ARE "PROPOSED" AND SHOWN FOR BIDDING PURPOSES ONLY. ACTUAL INVERT ELEVATIONS WILL BE CONFIRMED IN THE FIELD.

BELMONT / WATERTOWN
TRAPELO RD & BELMONT ST

STATE	FED. PROJ. AID NO.	SHEET NO.	TOTAL SHEETS
MASS.	xxxxx	103	214

PROJ. FILE NO. 604688

DRAINAGE & UTILITY PLAN

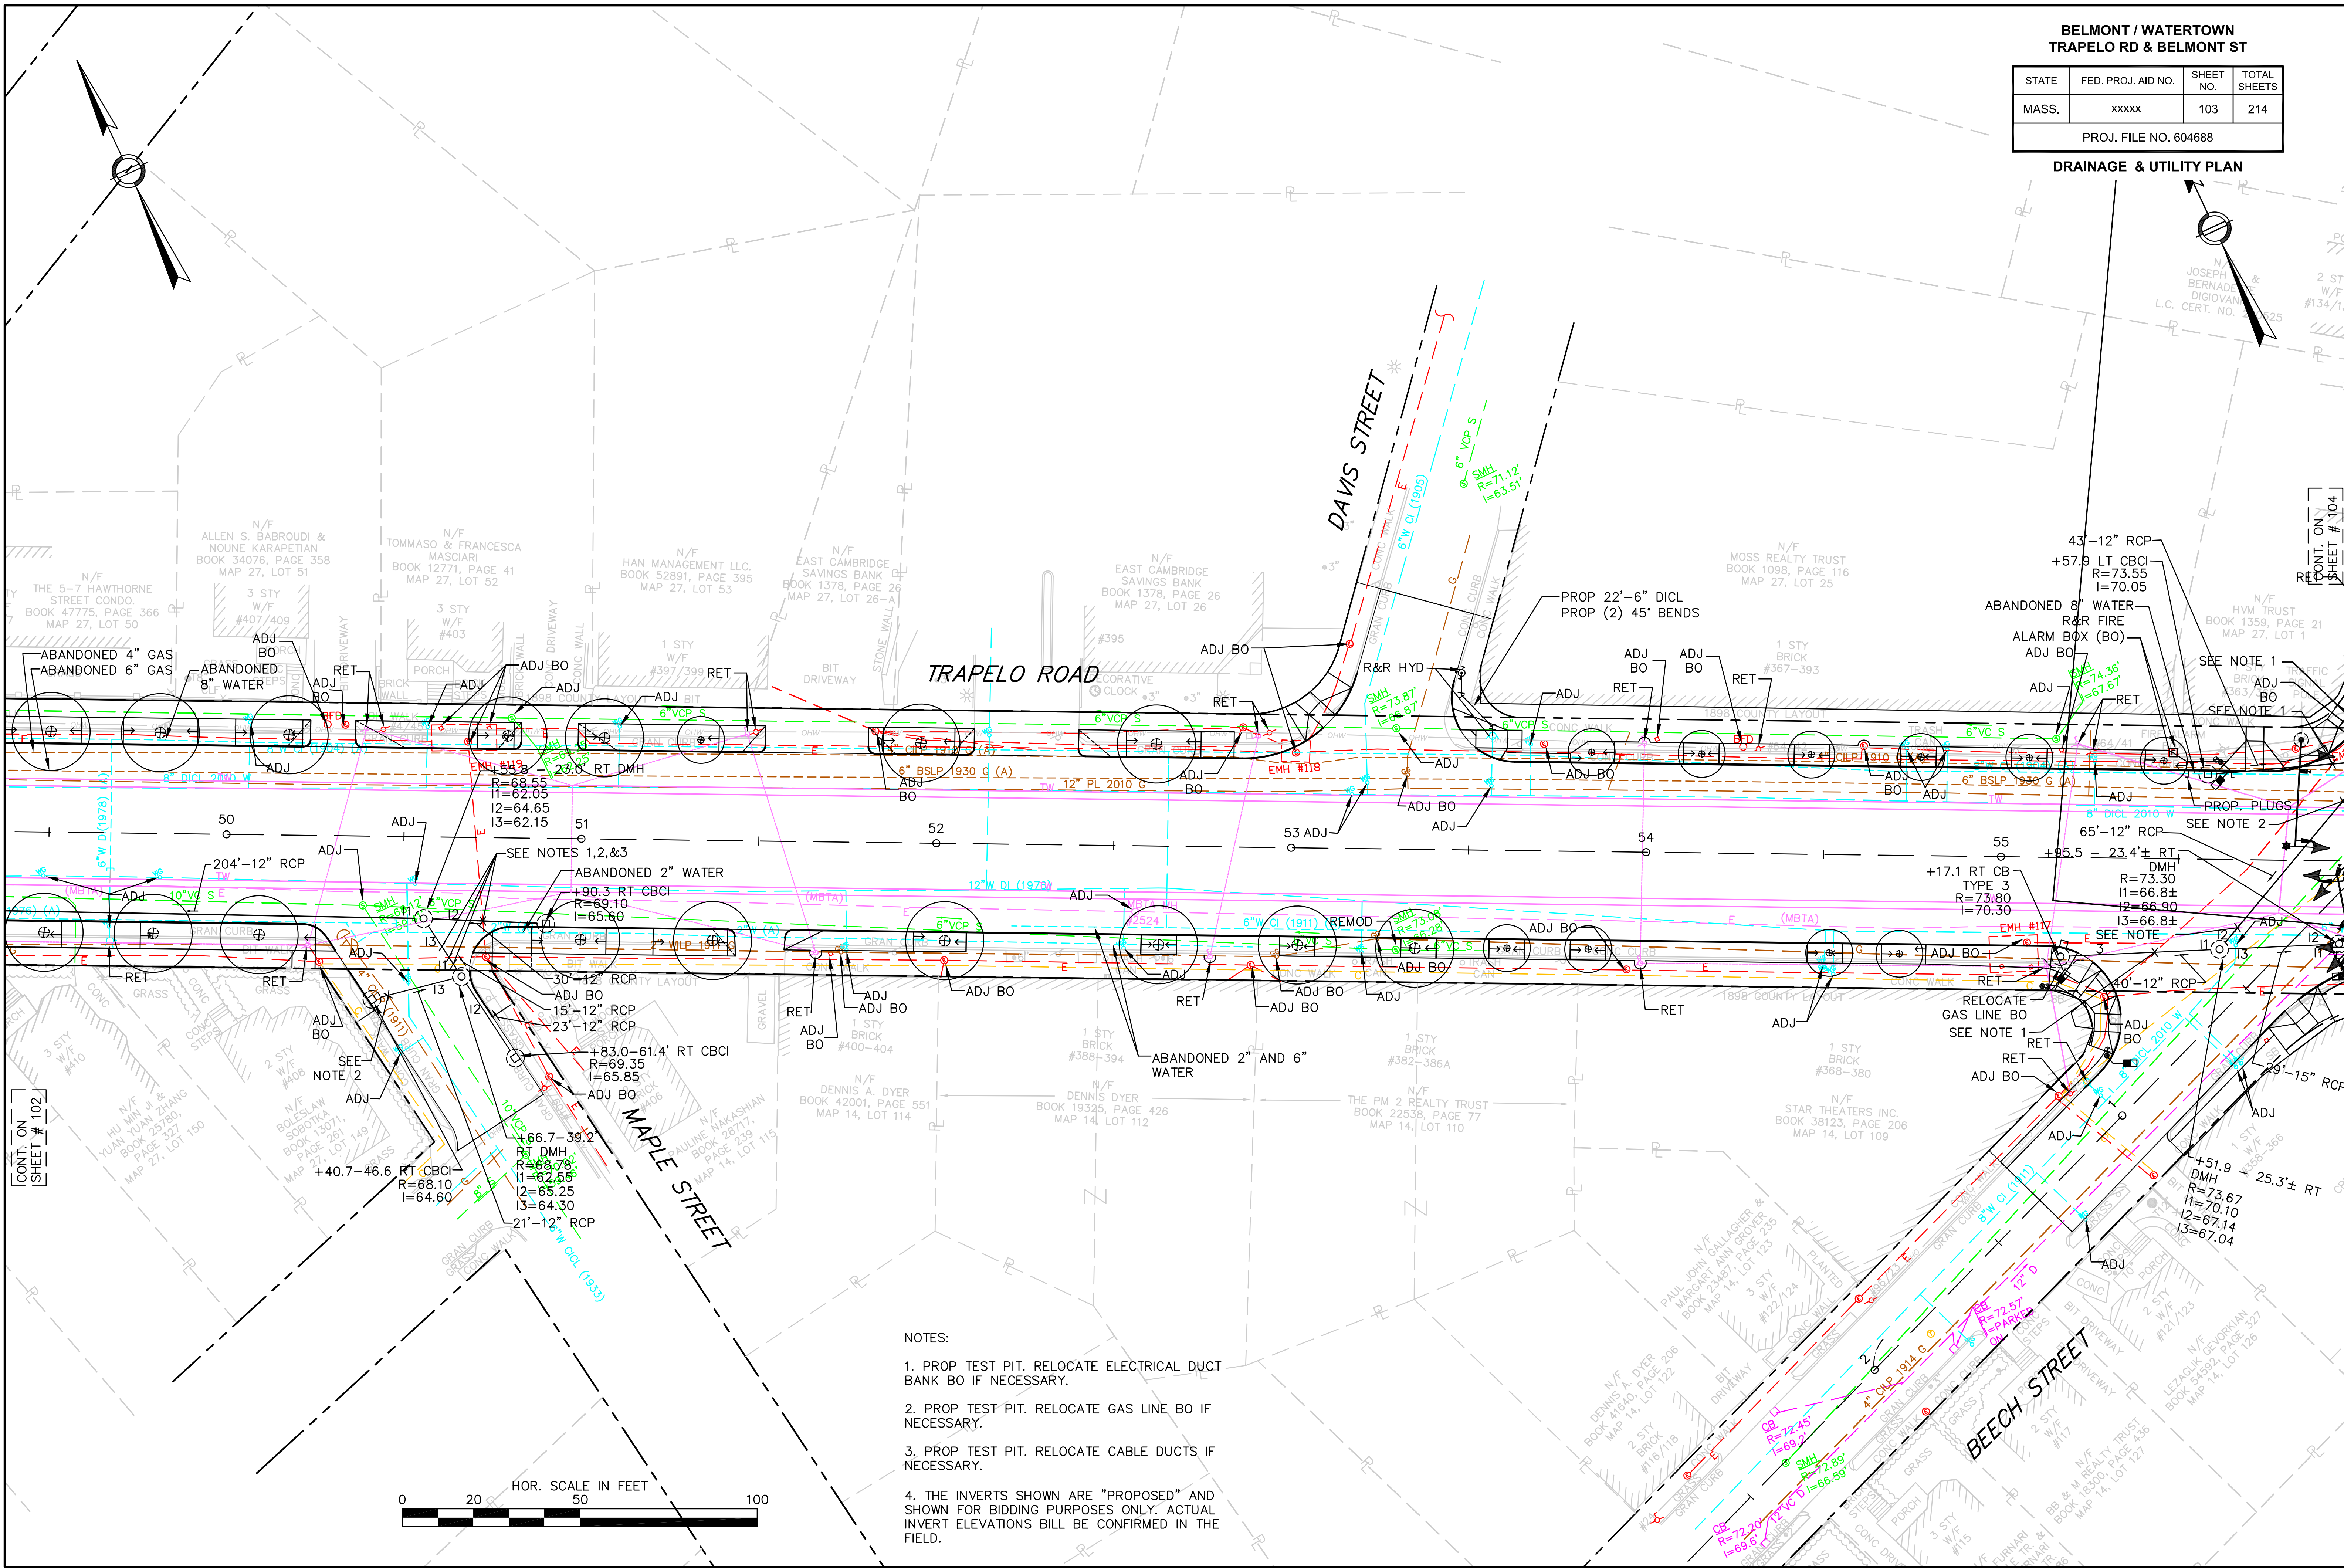

NOTES:

1. PROP TEST PIT. RELOCATE ELECTRICAL DUCT BANK BO IF NECESSARY.
2. PROP TEST PIT. RELOCATE GAS LINE BO IF NECESSARY.
3. PROP TEST PIT. RELOCATE CABLE DUCTS IF NECESSARY.
4. THE INVERTS SHOWN ARE "PROPOSED" AND SHOWN FOR BIDDING PURPOSES ONLY. ACTUAL INVERT ELEVATIONS WILL BE CONFIRMED IN THE FIELD.

STATE	FED. PROJ. AID NO.	SHEET NO.	TOTAL SHEETS
MASS.	xxxxx	104	214

**BELMONT / WATERTOWN
TRAPEZO RD & BELMONT ST**

STATE	FED. PROJ. AID NO.	SHEET NO.	TOTAL SHEETS
MASS.	XXXXX	104	214

PROJ. FILE NO. 604688

DRAINAGE & UTILITY PLAN

TRAPEZO ROAD

BEECH STREET

HULL STREET

WALNUT STREET

NOTES:


1. PROP. TEST PIT. RELOCATE ELECTRICAL DUCT BANK BO IF NECESSARY.
2. PROP. TEST PIT. RELOCATE GAS LINE BO IF NECESSARY.
3. PROP. TEST PIT. RELOCATE MBTA ELECTRICAL DUCT BANK BO IF NECESSARY.
4. PROP. TEST PIT. RELOCATE CABLE DUCTS IF NECESSARY.
5. PROP. TEST PIT. RELOCATE WATER LINE IF NECESSARY.
6. THE INVERTS SHOWN ARE "PROPOSED" AND SHOWN FOR BIDDING PURPOSES ONLY. ACTUAL INVERT ELEVATIONS WILL BE CONFIRMED IN THE FIELD.

1. PROP TEST PIT. RELOCATE ELECTRICAL DUCT BANK BO IF NECESSARY.
2. PROP TEST PIT. RELOCATE GAS LINE BO IF NECESSARY.
3. PROP TEST PIT. RELOCATE MBTA ELECTRICAL DUCT BANK BO IF NECESSARY.
4. PROP TEST PIT. RELOCATE CABLE DUCTS IF NECESSARY.
5. PROP TEST PIT. RELOCATE WATER LINE IF NECESSARY
6. THE INVERTS SHOWN ARE "PROPOSED" AND SHOWN FOR BIDDING PURPOSES ONLY. ACTUAL INVERT ELEVATIONS WILL BE CONFIRMED IN THE FIELD.

BELMONT / WATERTOWN
TRAPELO RD & BELMONT ST

STATE	FED. PROJ. AID NO.	SHEET NO.	TOTAL SHEETS
MASS.	xxxxx	105	214
PROJ. FILE NO. 604688			

DRAINAGE & UTILITY PLAN

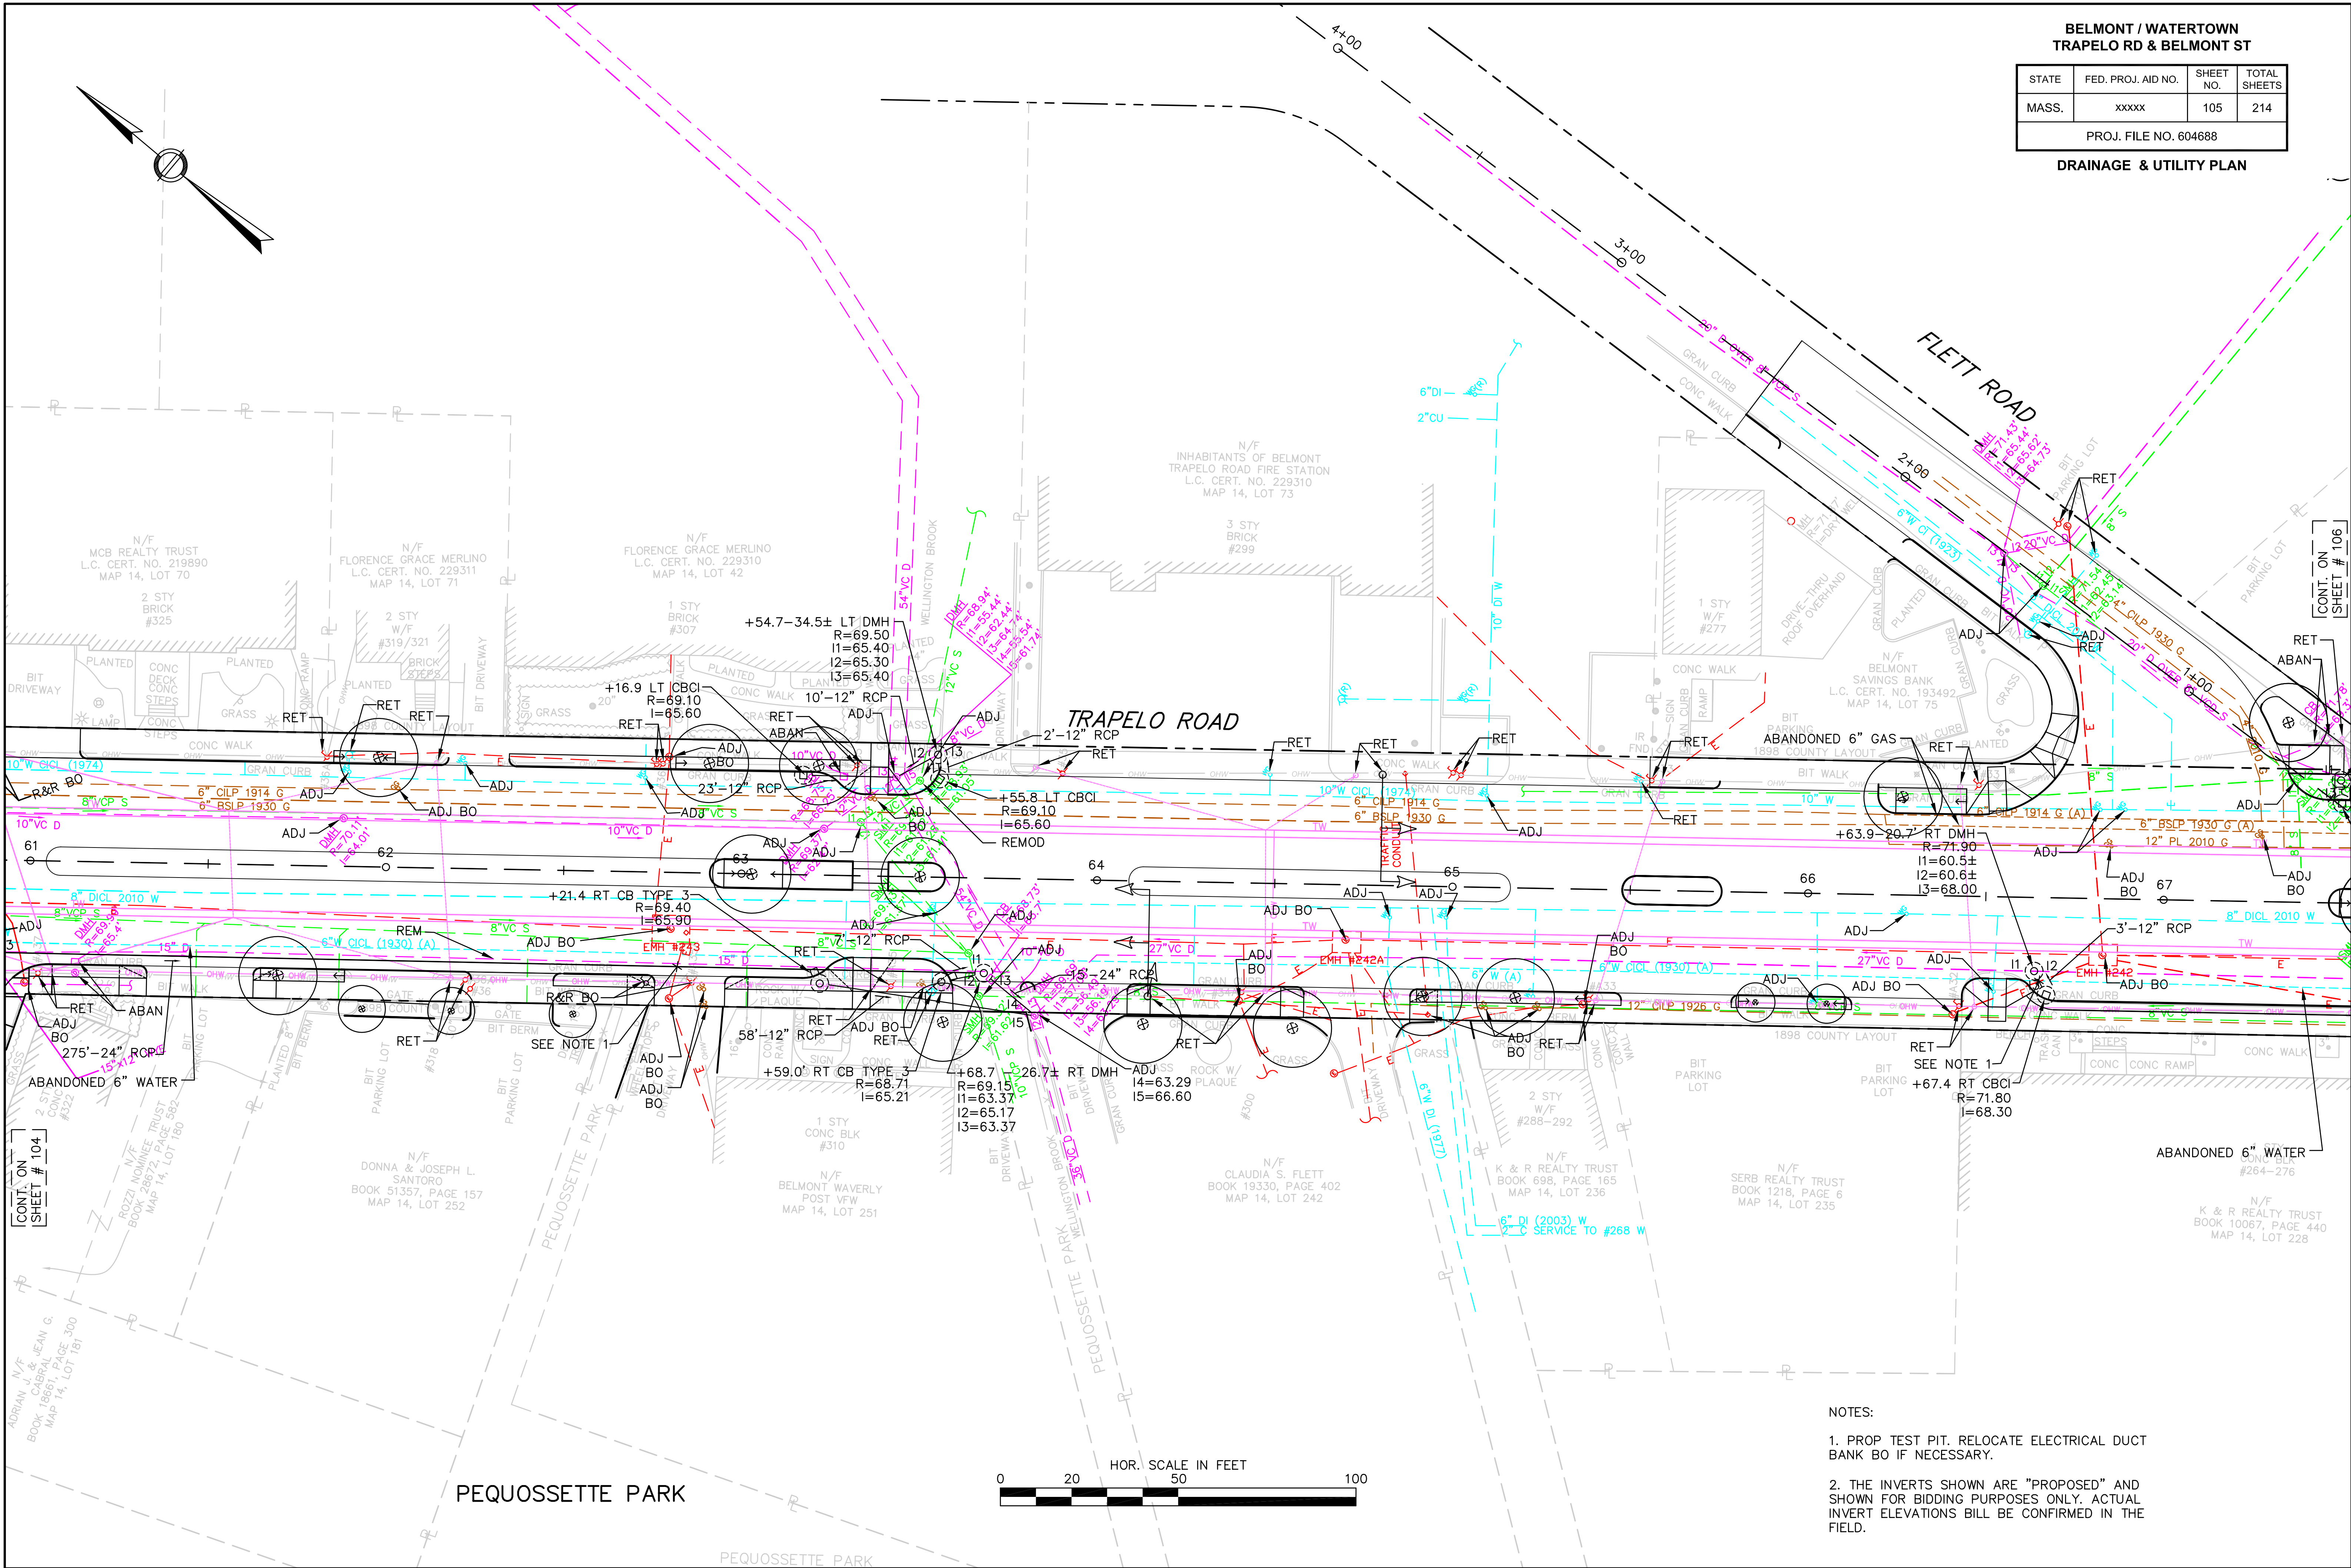


- NOTES:
1. PROP TEST PIT. RELOCATE ELECTRICAL DUCT BANK BO IF NECESSARY.
 2. THE INVERTS SHOWN ARE "PROPOSED" AND SHOWN FOR BIDDING PURPOSES ONLY. ACTUAL INVERT ELEVATIONS WILL BE CONFIRMED IN THE FIELD.

BELMONT / WATERTOWN
TRAPELO RD & BELMONT ST


STATE	FED. PROJ. AID NO.	SHEET NO.	TOTAL SHEETS
MASS.	xxxxx	106	214
PROJ. FILE NO. 604688			

DRAINAGE & UTILITY PLAN

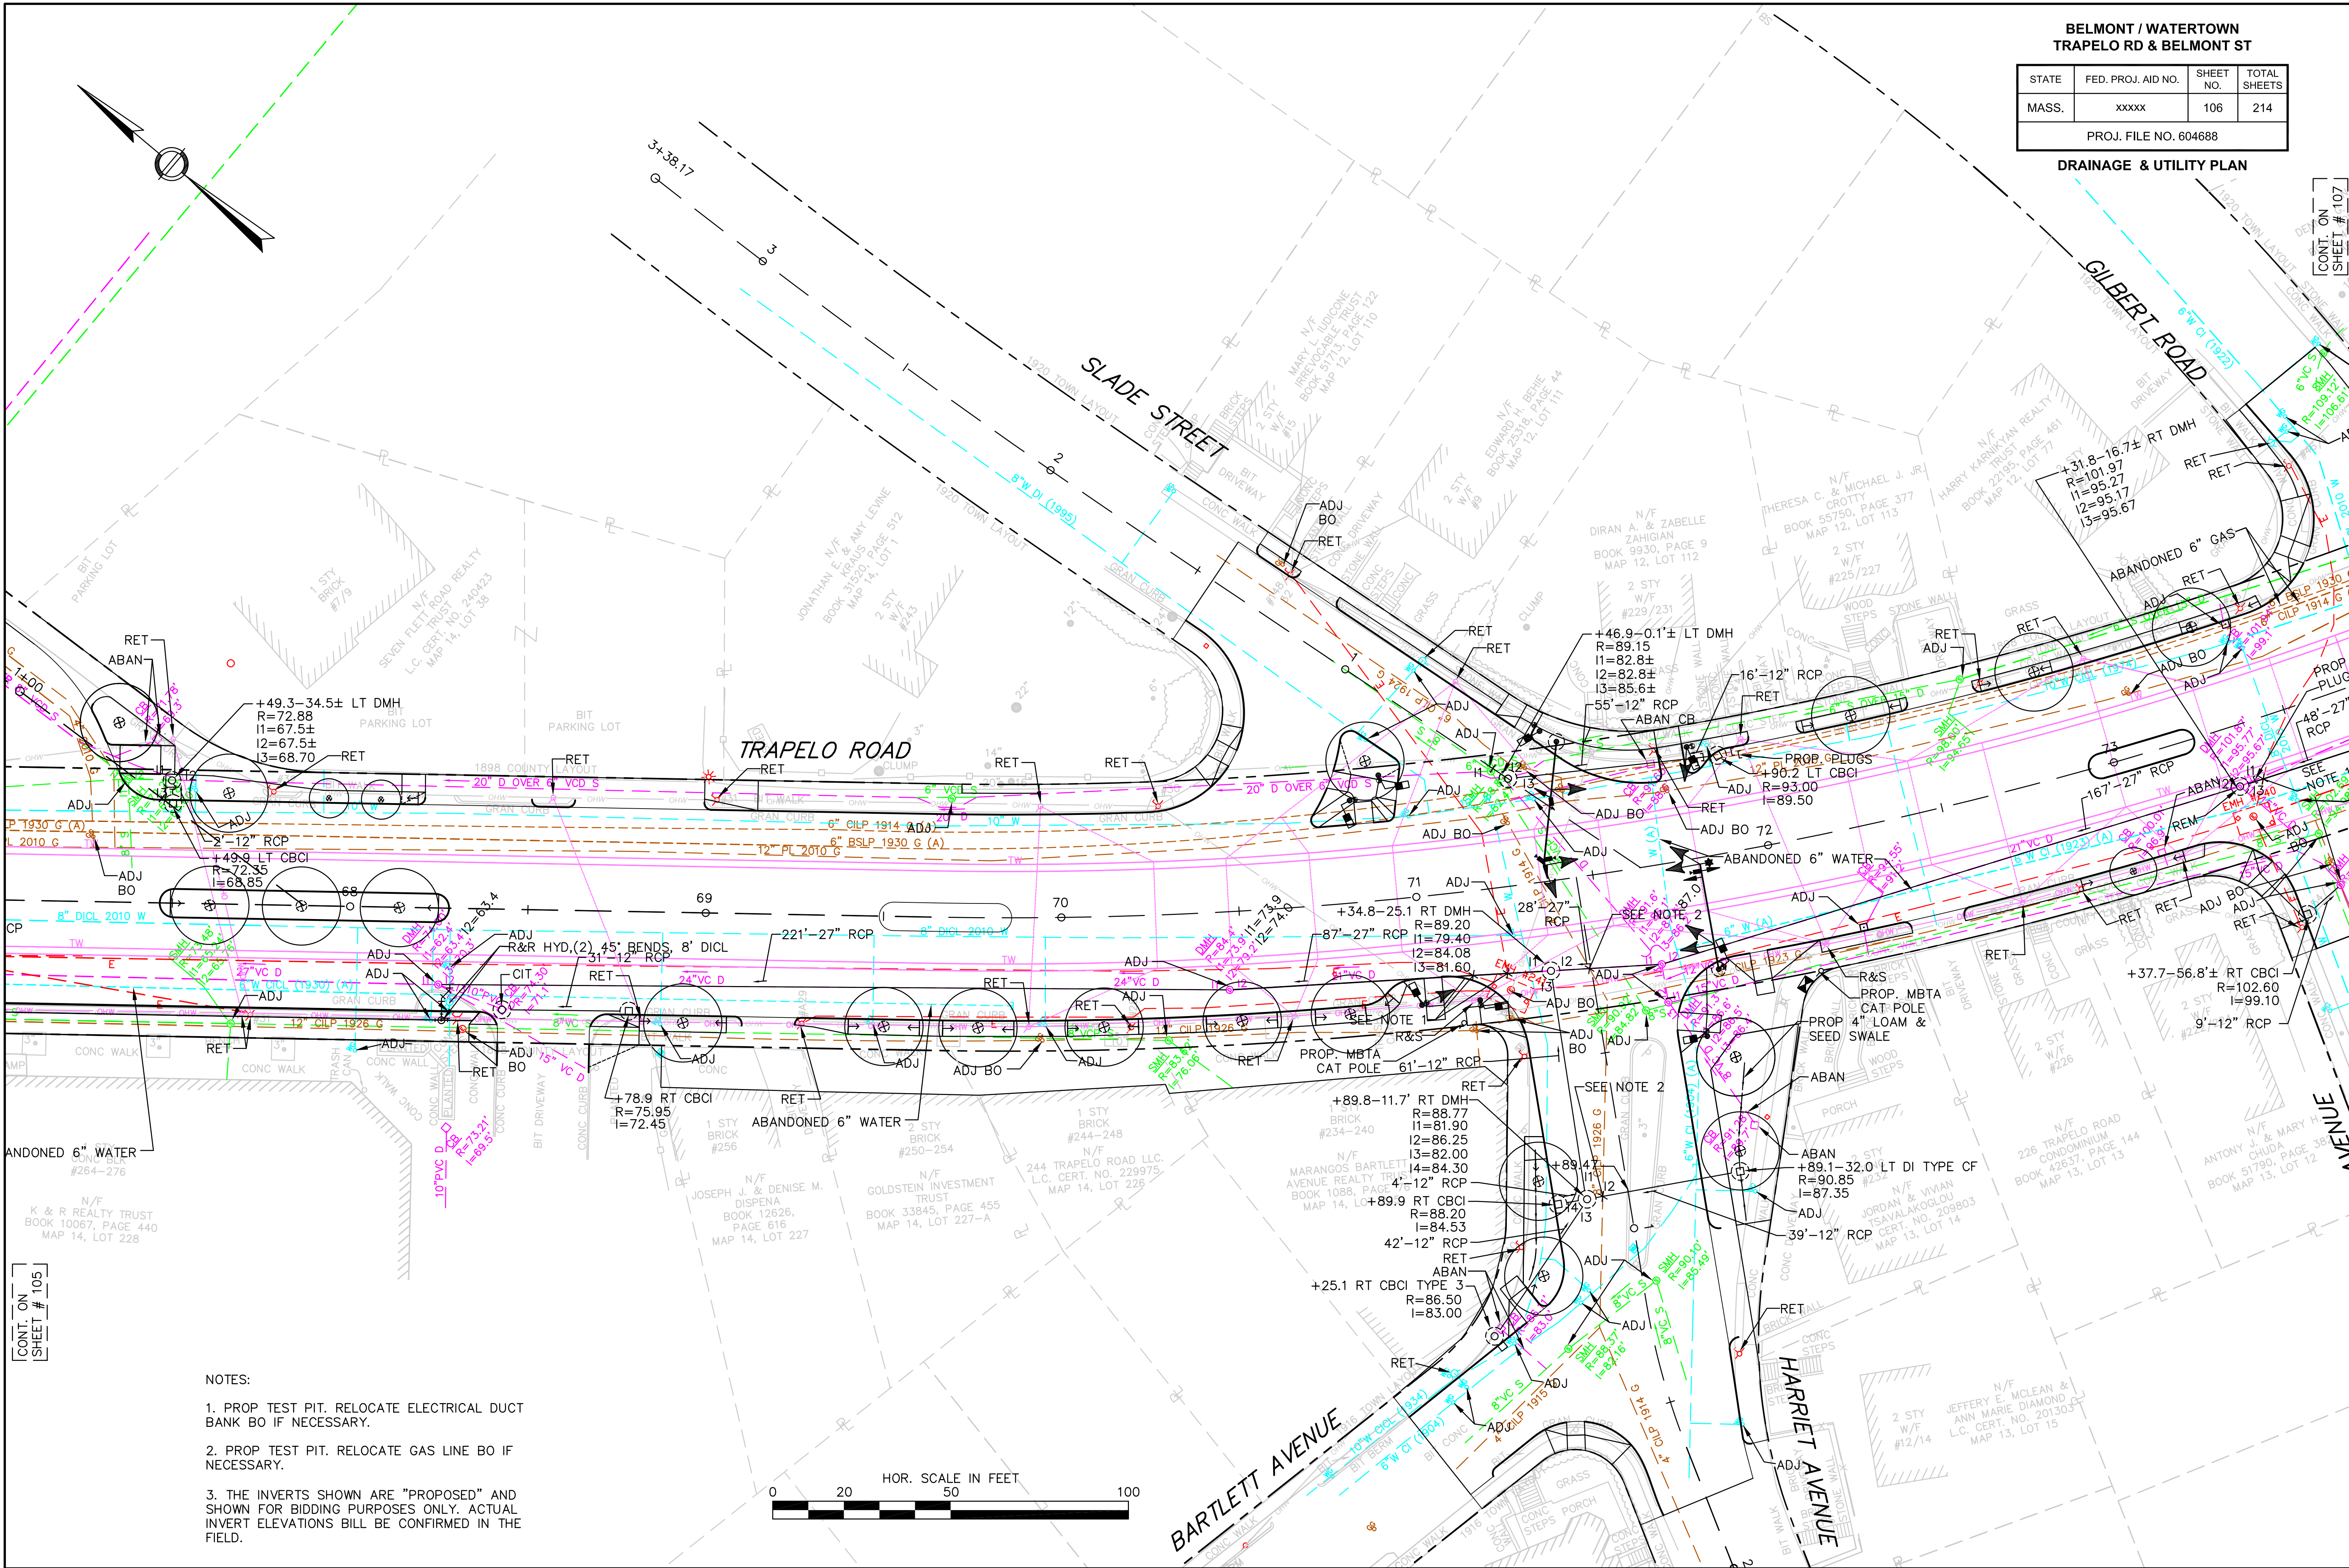

NOTES:

1. PROP TEST PIT. RELOCATE ELECTRICAL DUCT BANK BO IF NECESSARY.
2. PROP TEST PIT. RELOCATE GAS LINE BO IF NECESSARY.
3. THE INVERTS SHOWN ARE "PROPOSED" AND SHOWN FOR BIDDING PURPOSES ONLY. ACTUAL INVERT ELEVATIONS WILL BE CONFIRMED IN THE FIELD.

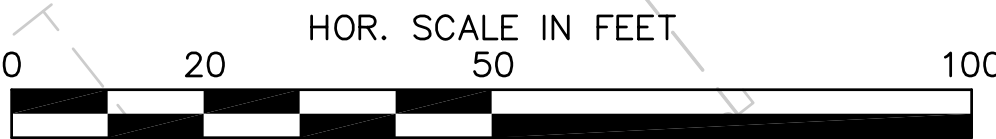


BELMONT / WATERTOWN
TRAPELO RD & BELMONT ST

STATE	FED. PROJ. AID NO.	SHEET NO.	TOTAL SHEETS
MASS.	xxxxx	107	214

PROJ. FILE NO. 604688

DRAINAGE & UTILITY PLAN

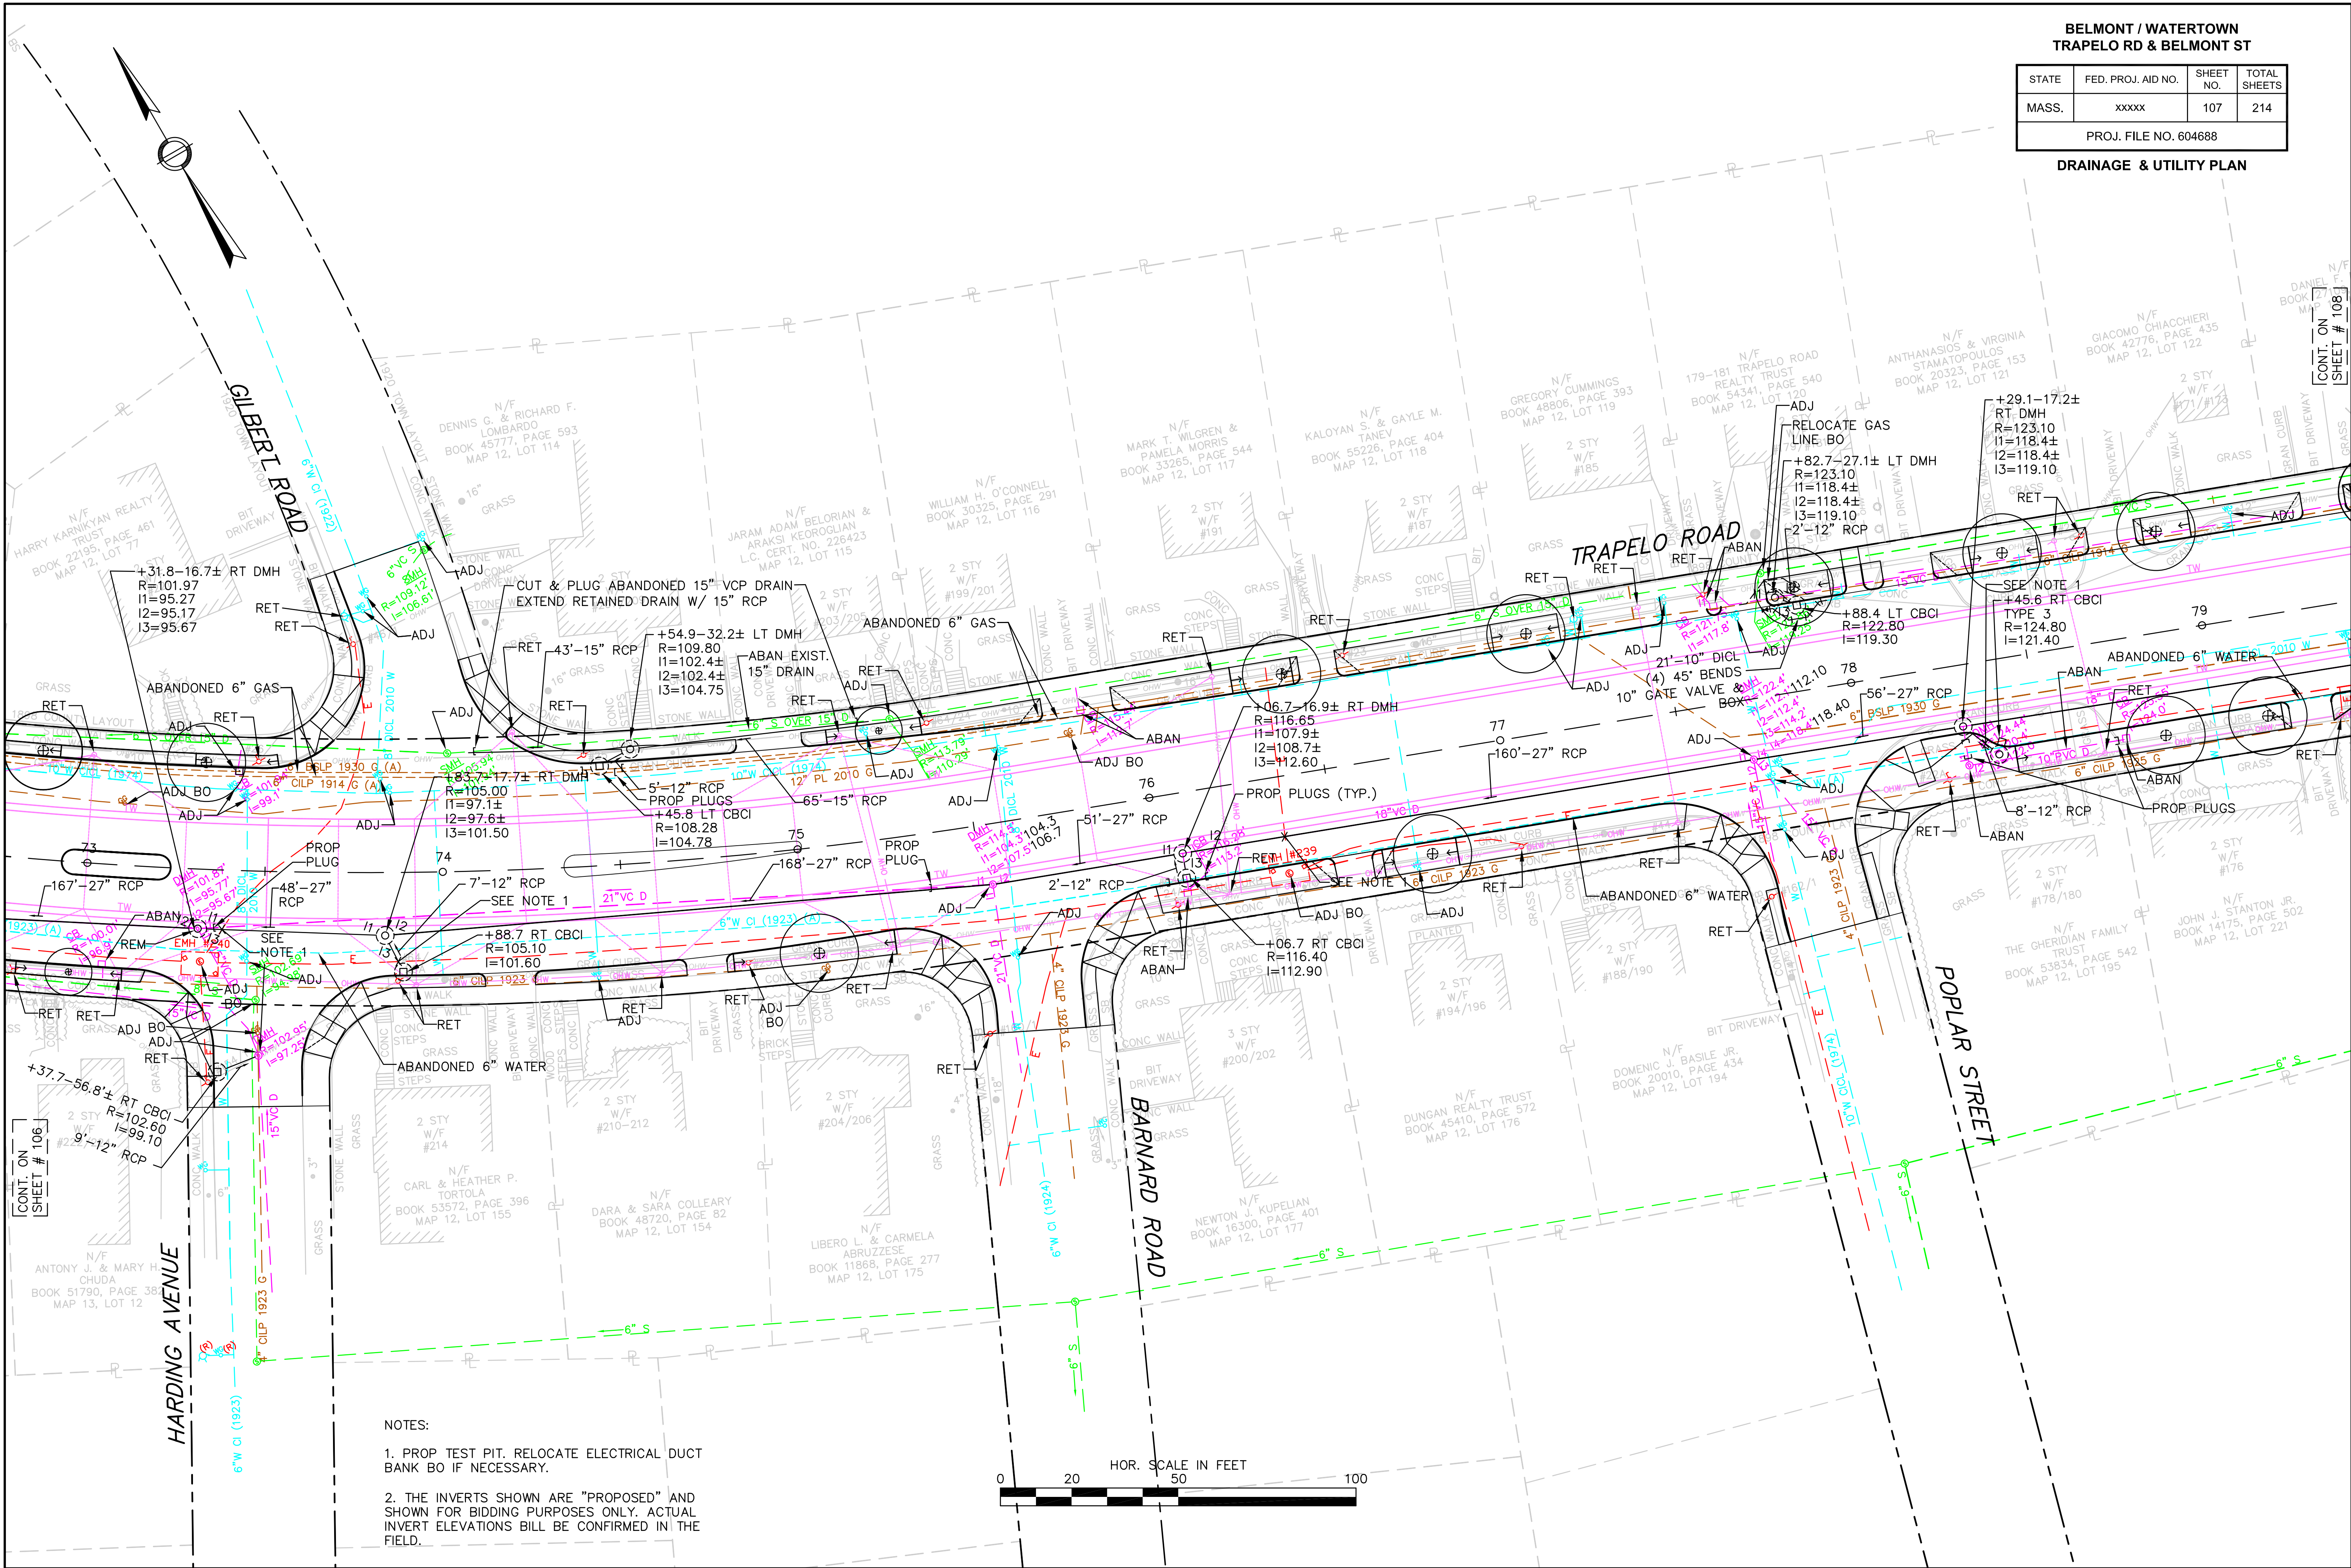


NOTES:

1. PROP. TEST PIT. RELOCATE ELECTRICAL DUCT BANK BO IF NECESSARY.
2. THE INVERTS SHOWN ARE "PROPOSED" AND SHOWN FOR BIDDING PURPOSES ONLY. ACTUAL INVERT ELEVATIONS WILL BE CONFIRMED IN THE FIELD.

BELMONT / WATERTOWN
TRAPELO RD & BELMONT ST


STATE	FED. PROJ. AID NO.	SHEET NO.	TOTAL SHEETS
MASS.	xxxxx	108	214
PROJ. FILE NO. 604688			

DRAINAGE & UTILITY PLAN

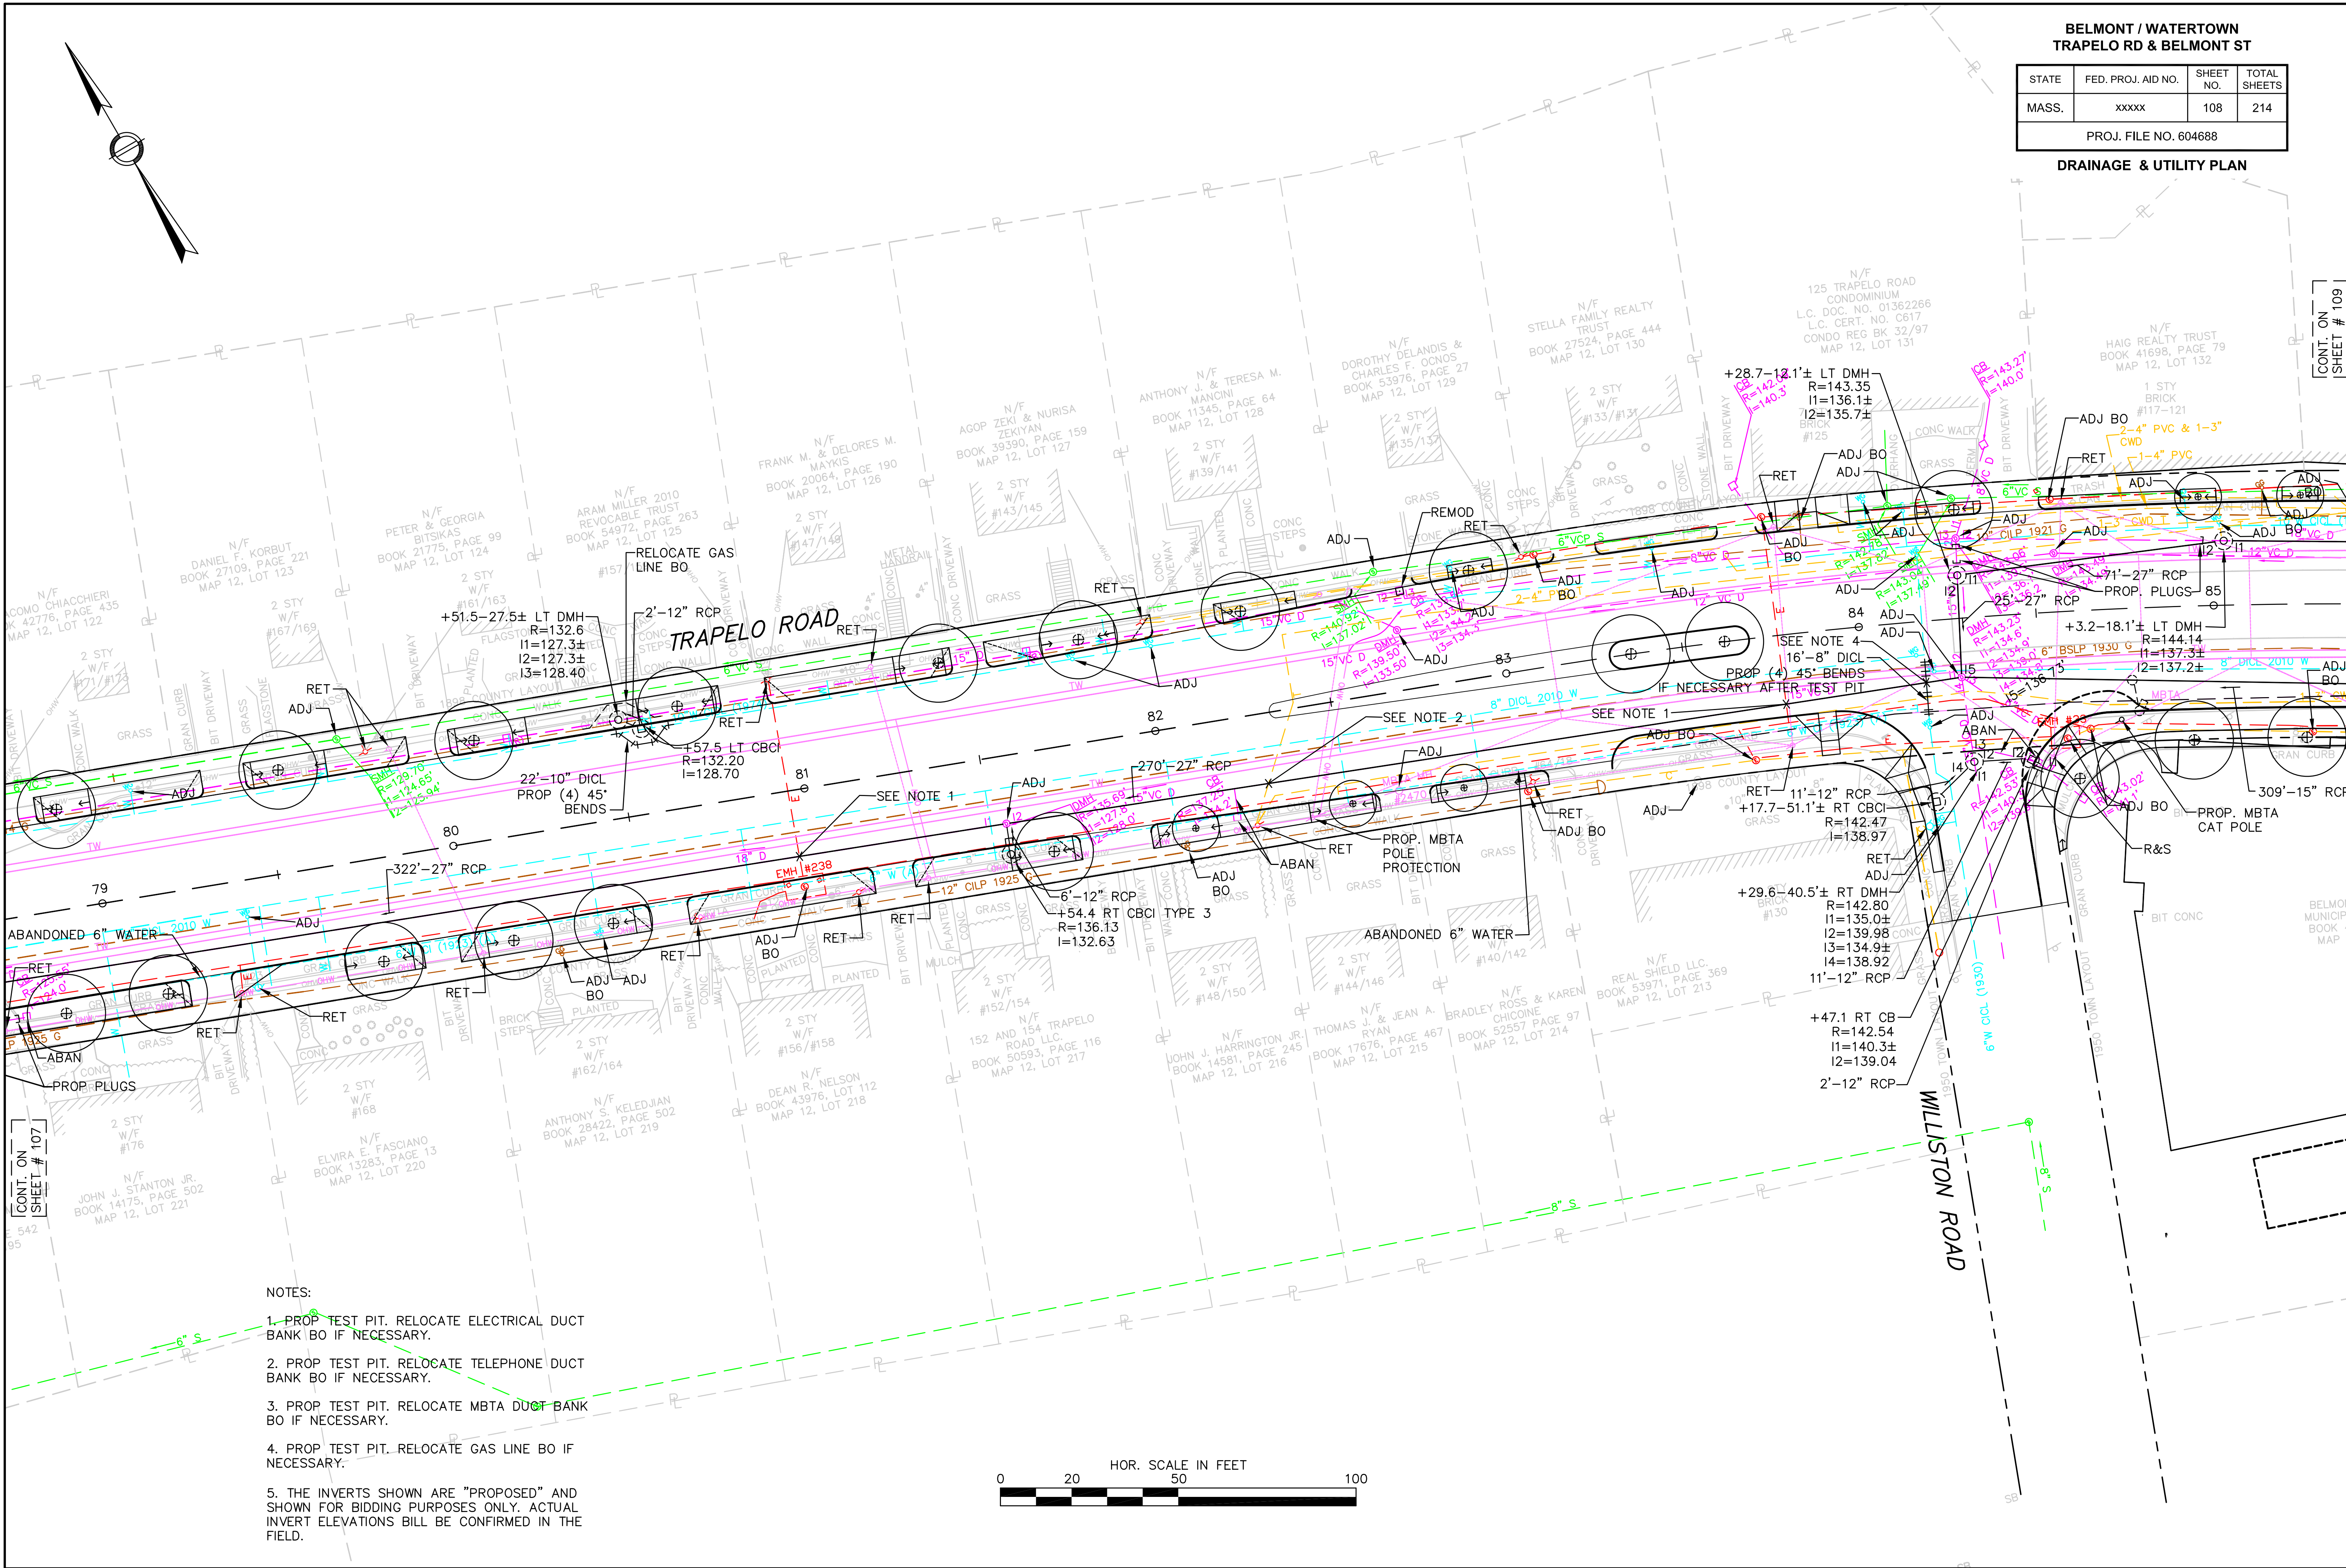

NOTES:

1. PROP TEST PIT. RELOCATE ELECTRICAL DUCT BANK BO IF NECESSARY.
2. PROP TEST PIT. RELOCATE TELEPHONE DUCT BANK BO IF NECESSARY.
3. PROP TEST PIT. RELOCATE MBTA DUCT BANK BO IF NECESSARY.
4. PROP TEST PIT. RELOCATE GAS LINE BO IF NECESSARY.
5. THE INVERTS SHOWN ARE "PROPOSED" AND SHOWN FOR BIDDING PURPOSES ONLY. ACTUAL INVERT ELEVATIONS WILL BE CONFIRMED IN THE FIELD.

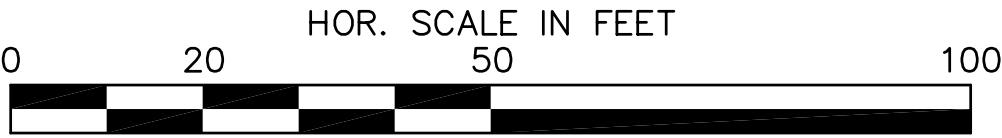



BELMONT / WATERTOWN
TRAPELO RD & BELMONT ST

STATE	FED. PROJ. AID NO.	SHEET NO.	TOTAL SHEETS
MASS.	XXXXX	109	214
PROJ. FILE NO. 604688			

DRAINAGE & UTILITY PLAN

NOTES:

1. PROP TEST PIT. RELOCATE ELECTRICAL DUCT BANK BO IF NECESSARY.
2. PROP TEST PIT. RELOCATE TELEPHONE DUCT BANK BO IF NECESSARY.
3. PROP TEST PIT. RELOCATE GAS LINE BO IF NECESSARY.
4. PROP TEST PIT. RELOCATE MBTA DUCT BANK BO IF NECESSARY.
5. THE INVERTS SHOWN ARE "PROPOSED" AND SHOWN FOR BIDDING PURPOSES ONLY. ACTUAL INVERT ELEVATIONS WILL BE CONFIRMED IN THE FIELD.

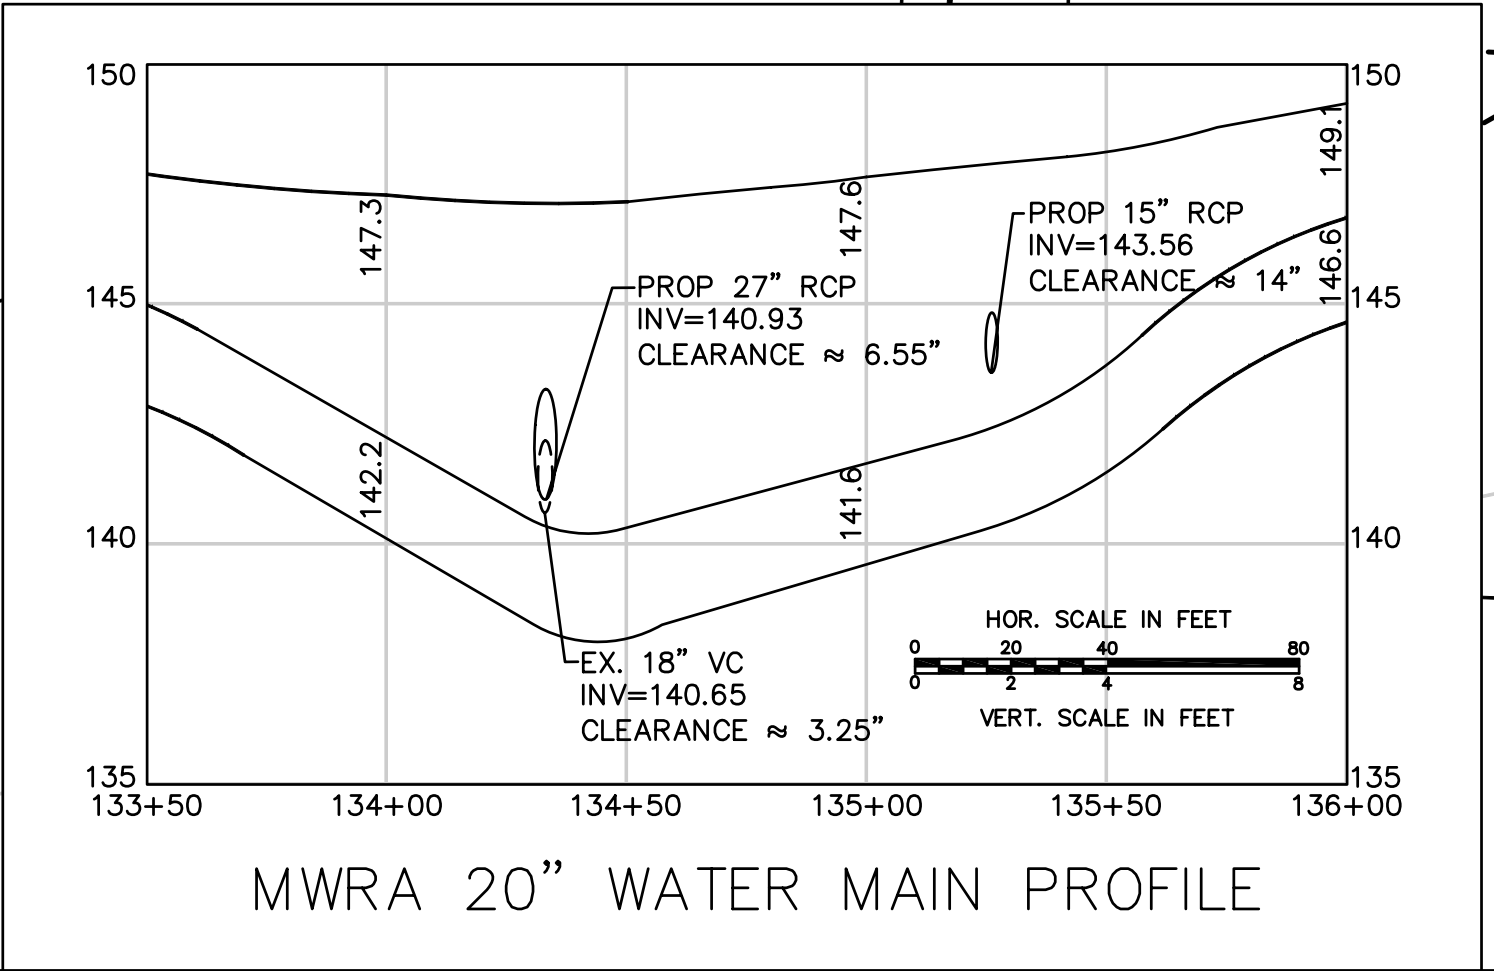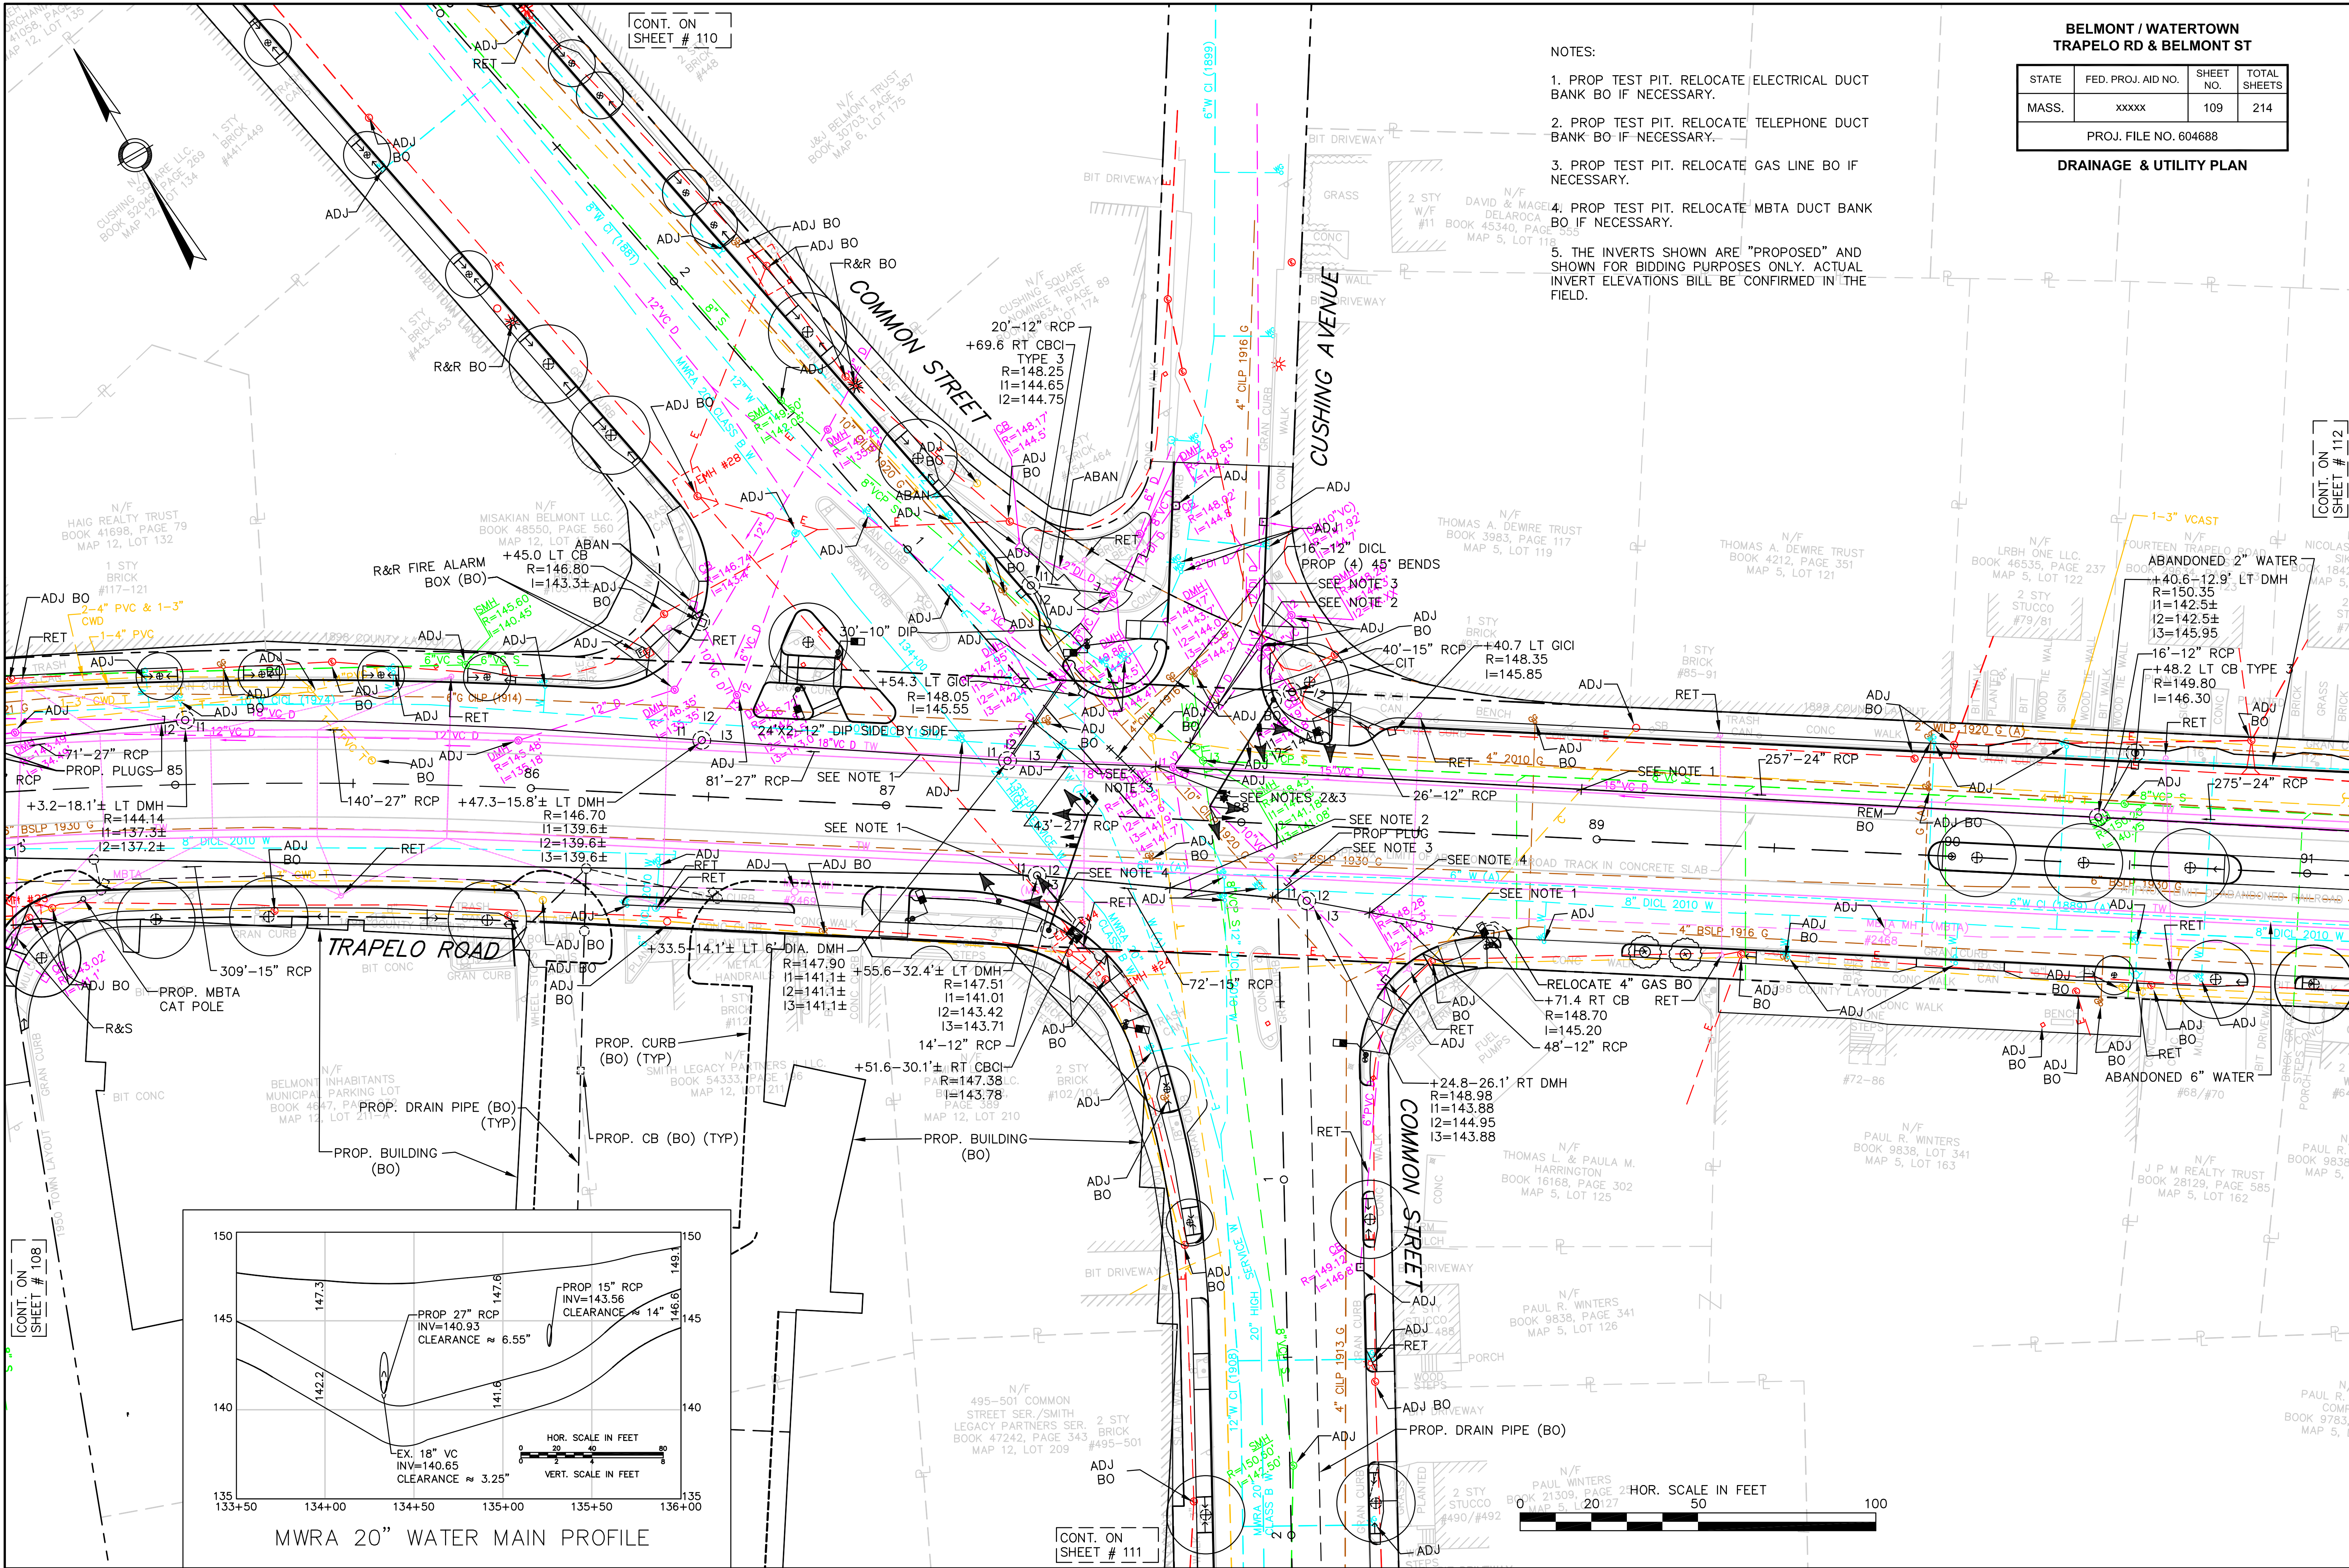


BELMONT / WATERTOWN
TRAPELO RD & BELMONT ST

STATE	FED. PROJ. AID NO.	SHEET NO.	TOTAL SHEETS
MASS.	xxxxx	110	214


PROJ. FILE NO. 604688

DRAINAGE & UTILITY PLAN

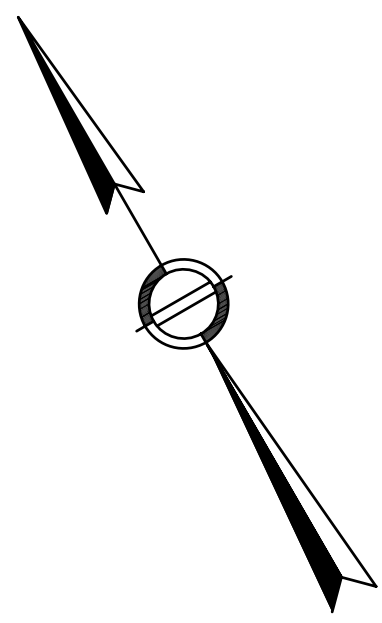


NOTES:

1. THE INVERTS SHOWN ARE "PROPOSED" AND SHOWN FOR BIDDING PURPOSES ONLY. ACTUAL INVERT ELEVATIONS WILL BE CONFIRMED IN THE FIELD.

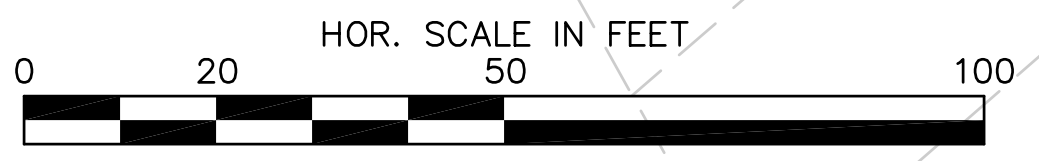


CONT. ON
SHEET # 109

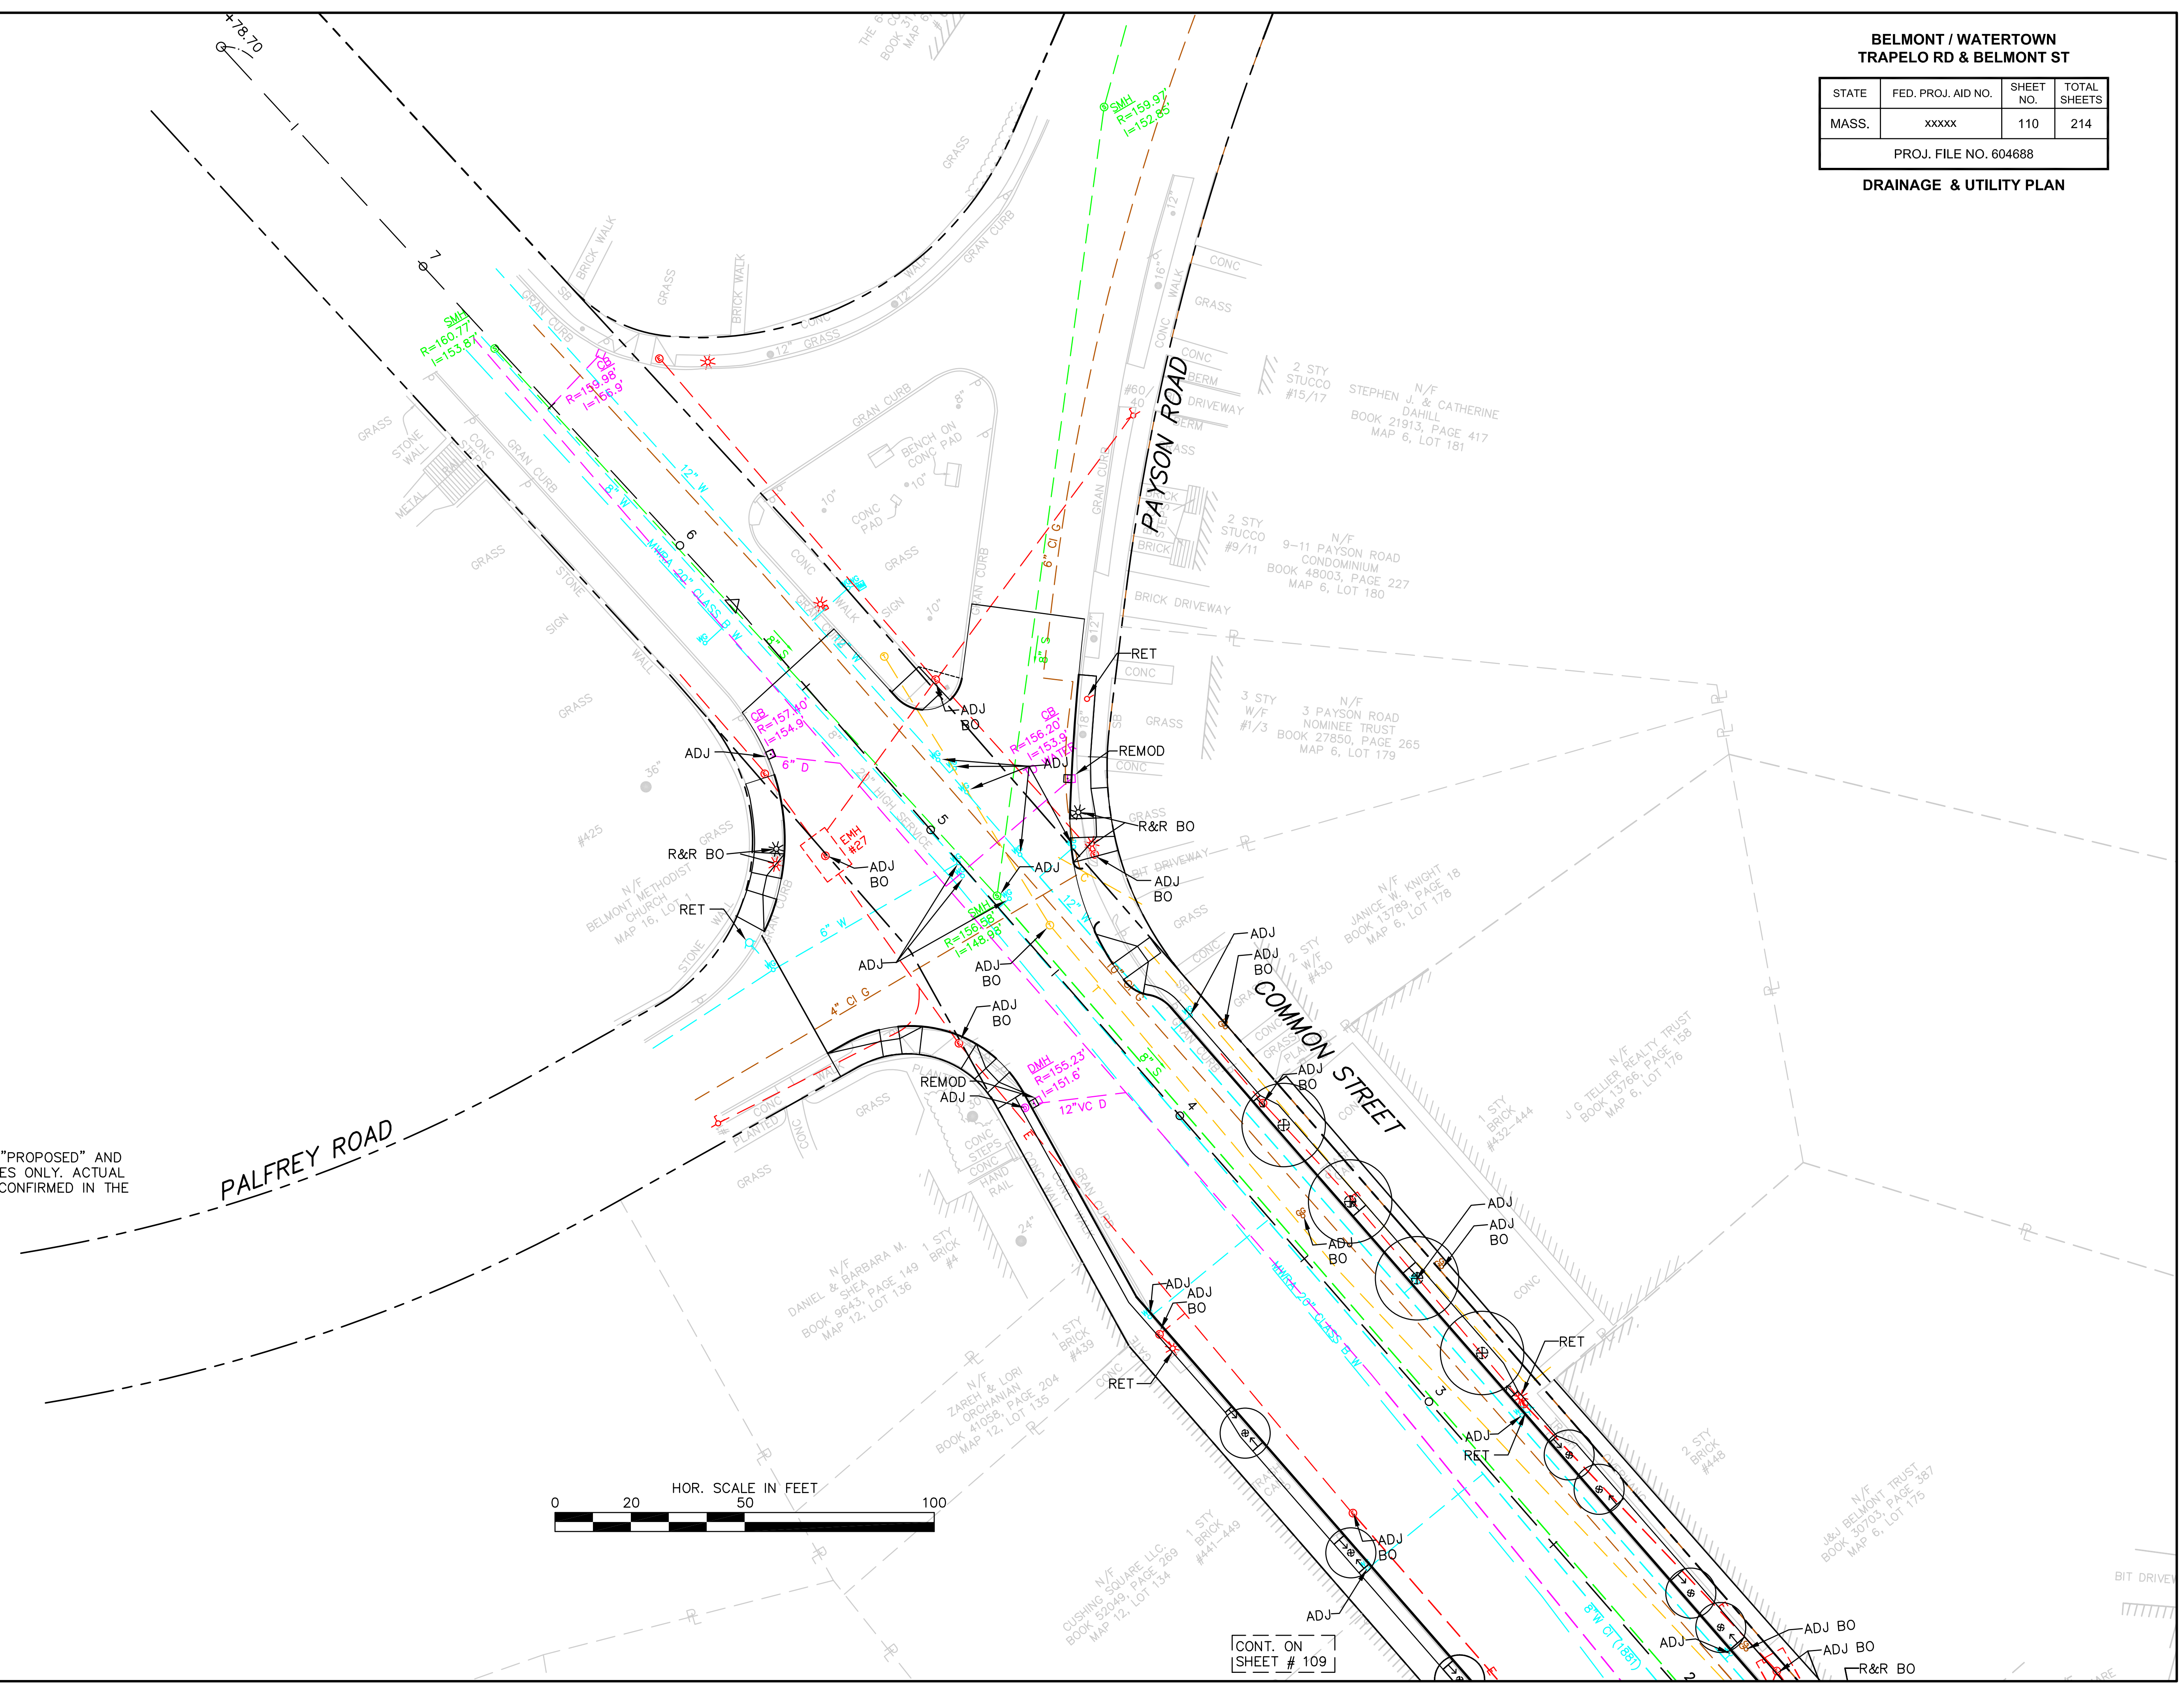

STATE	FED. PROJ. AID NO.	SHEET NO.	TOTAL SHEETS
MASS.	xxxxxx	111	214
PROJ. FILE NO. 604688			

NOTES:

1. THE INVERTS SHOWN ARE "PROPOSED" AND SHOWN FOR BIDDING PURPOSES ONLY. ACTUAL INVERT ELEVATIONS WILL BE CONFIRMED IN THE FIELD.

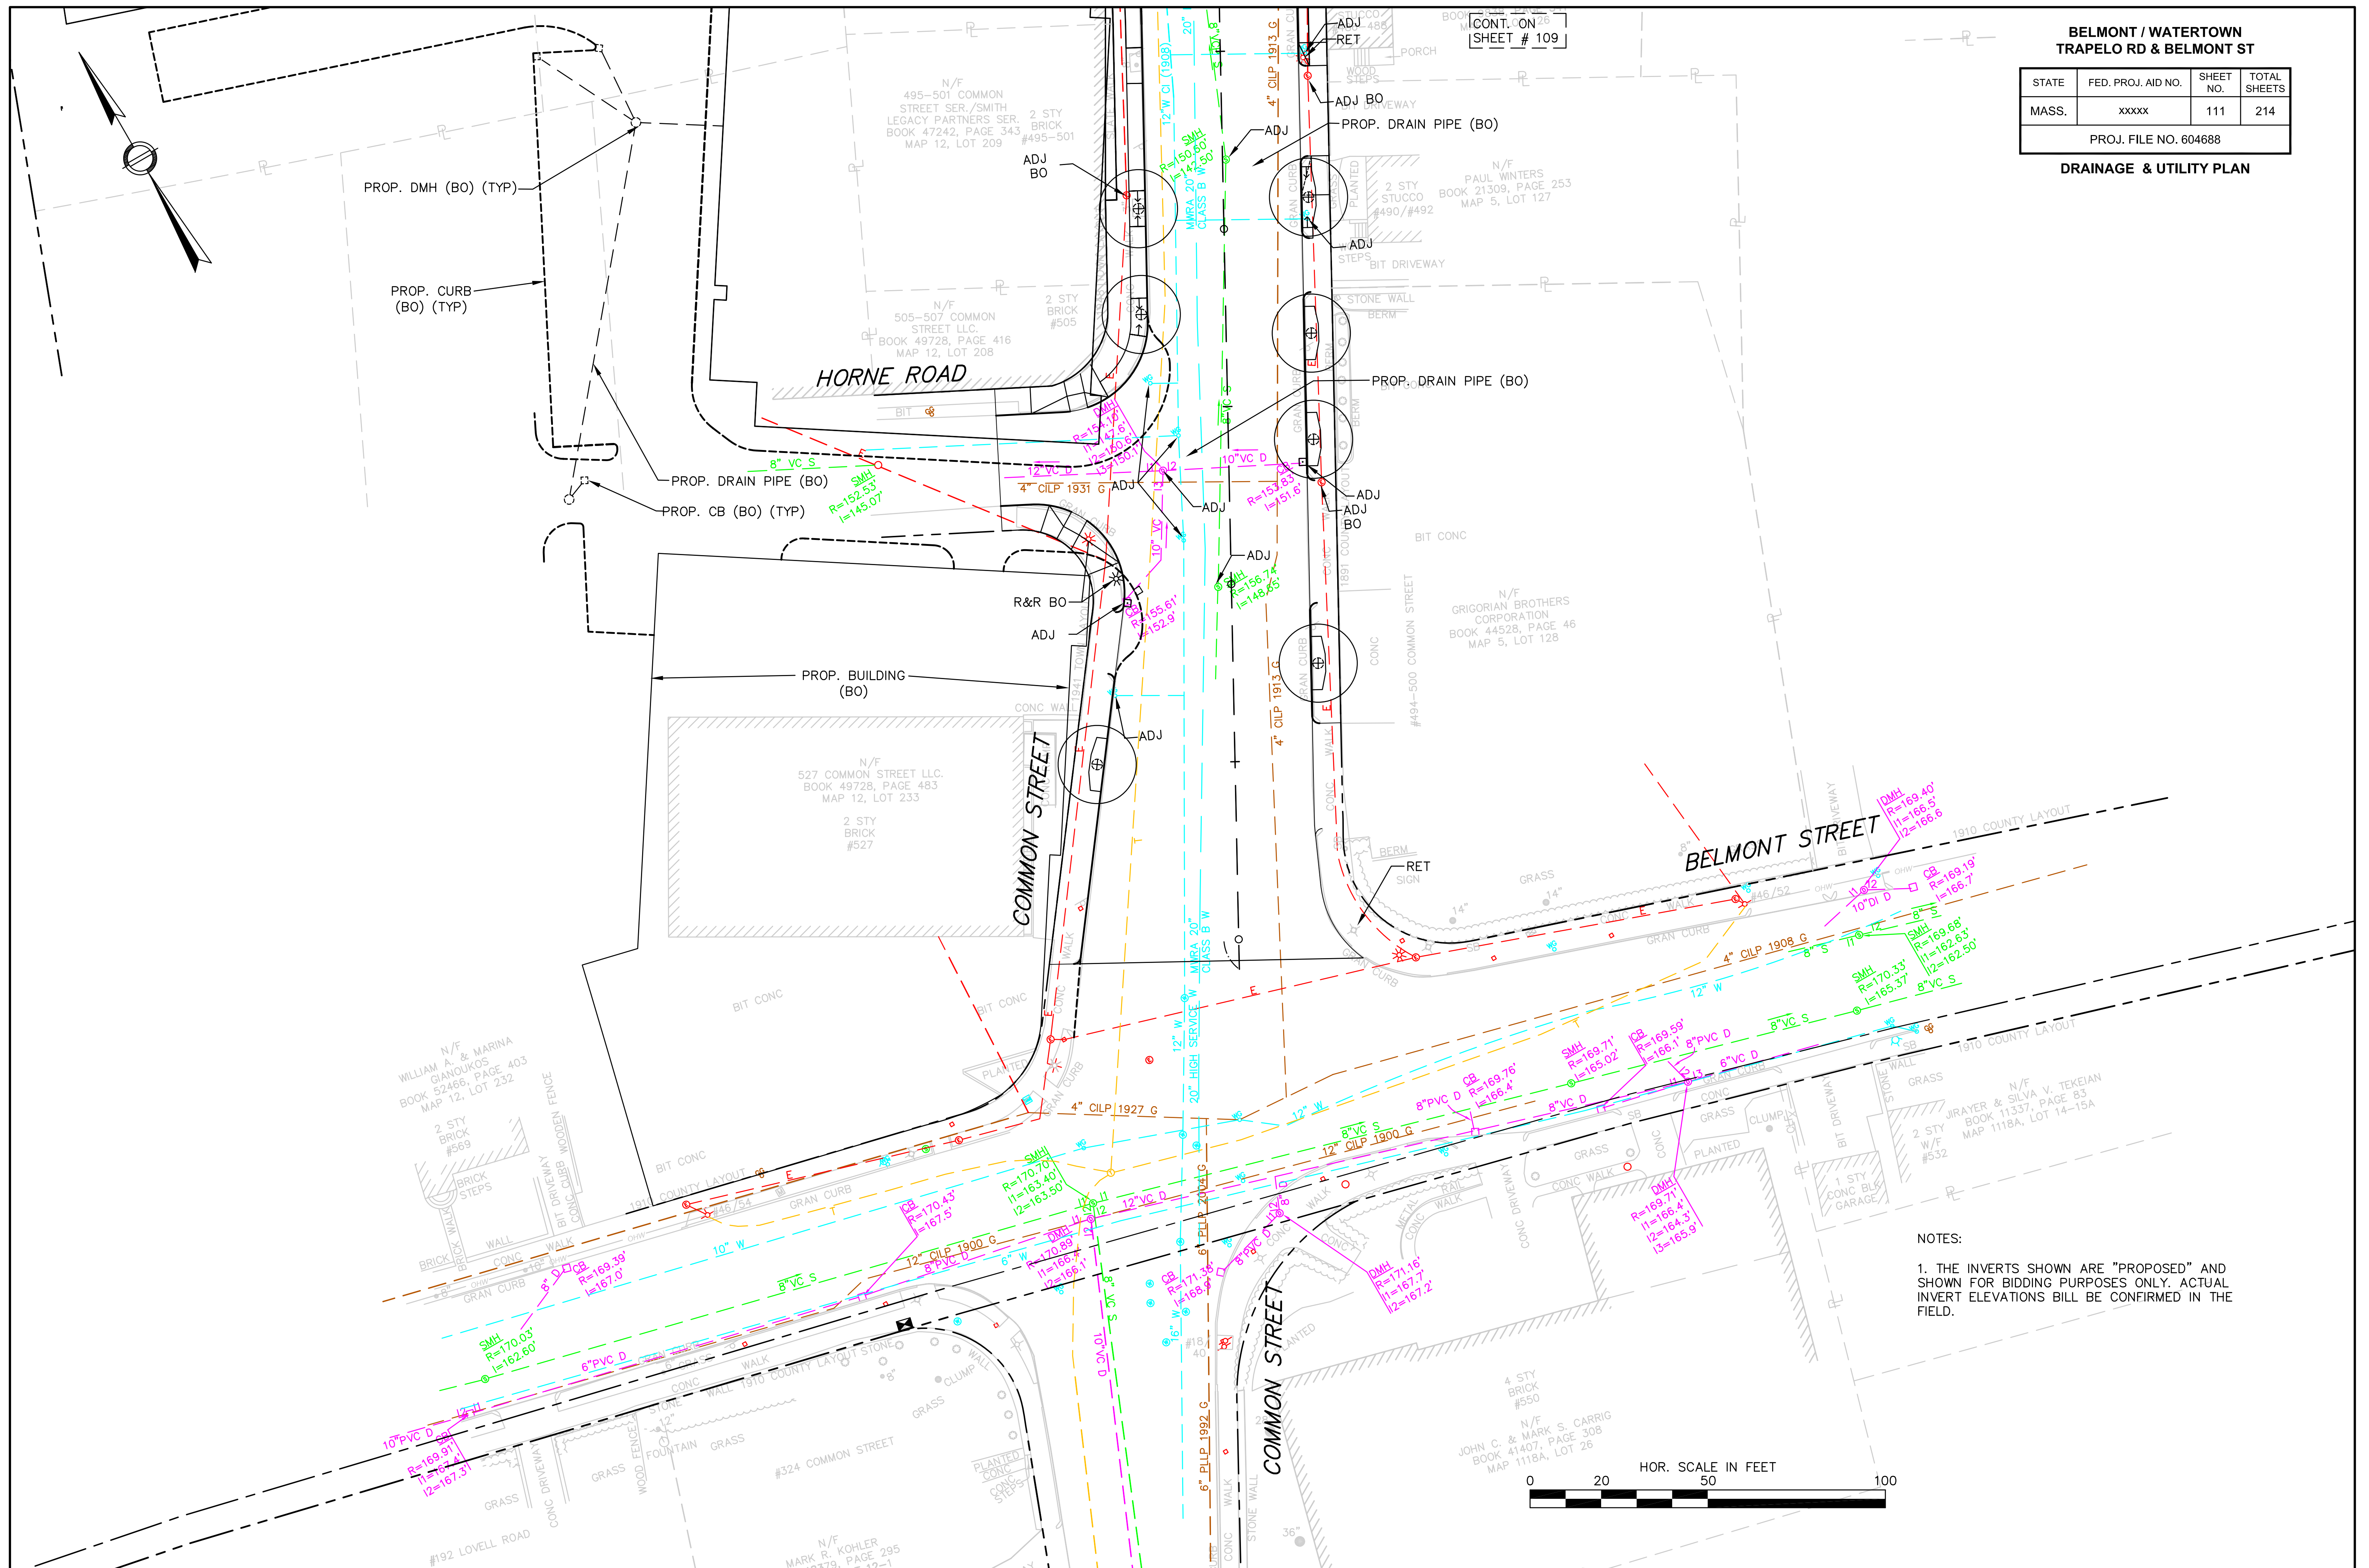


BELMONT / WATERTOWN
TRAPELO RD & BELMONT ST


STATE	FED. PROJ. AID NO.	SHEET NO.	TOTAL SHEETS
MASS.	xxxxx	112	214

PROJ. FILE NO. 604688

DRAINAGE & UTILITY PLAN

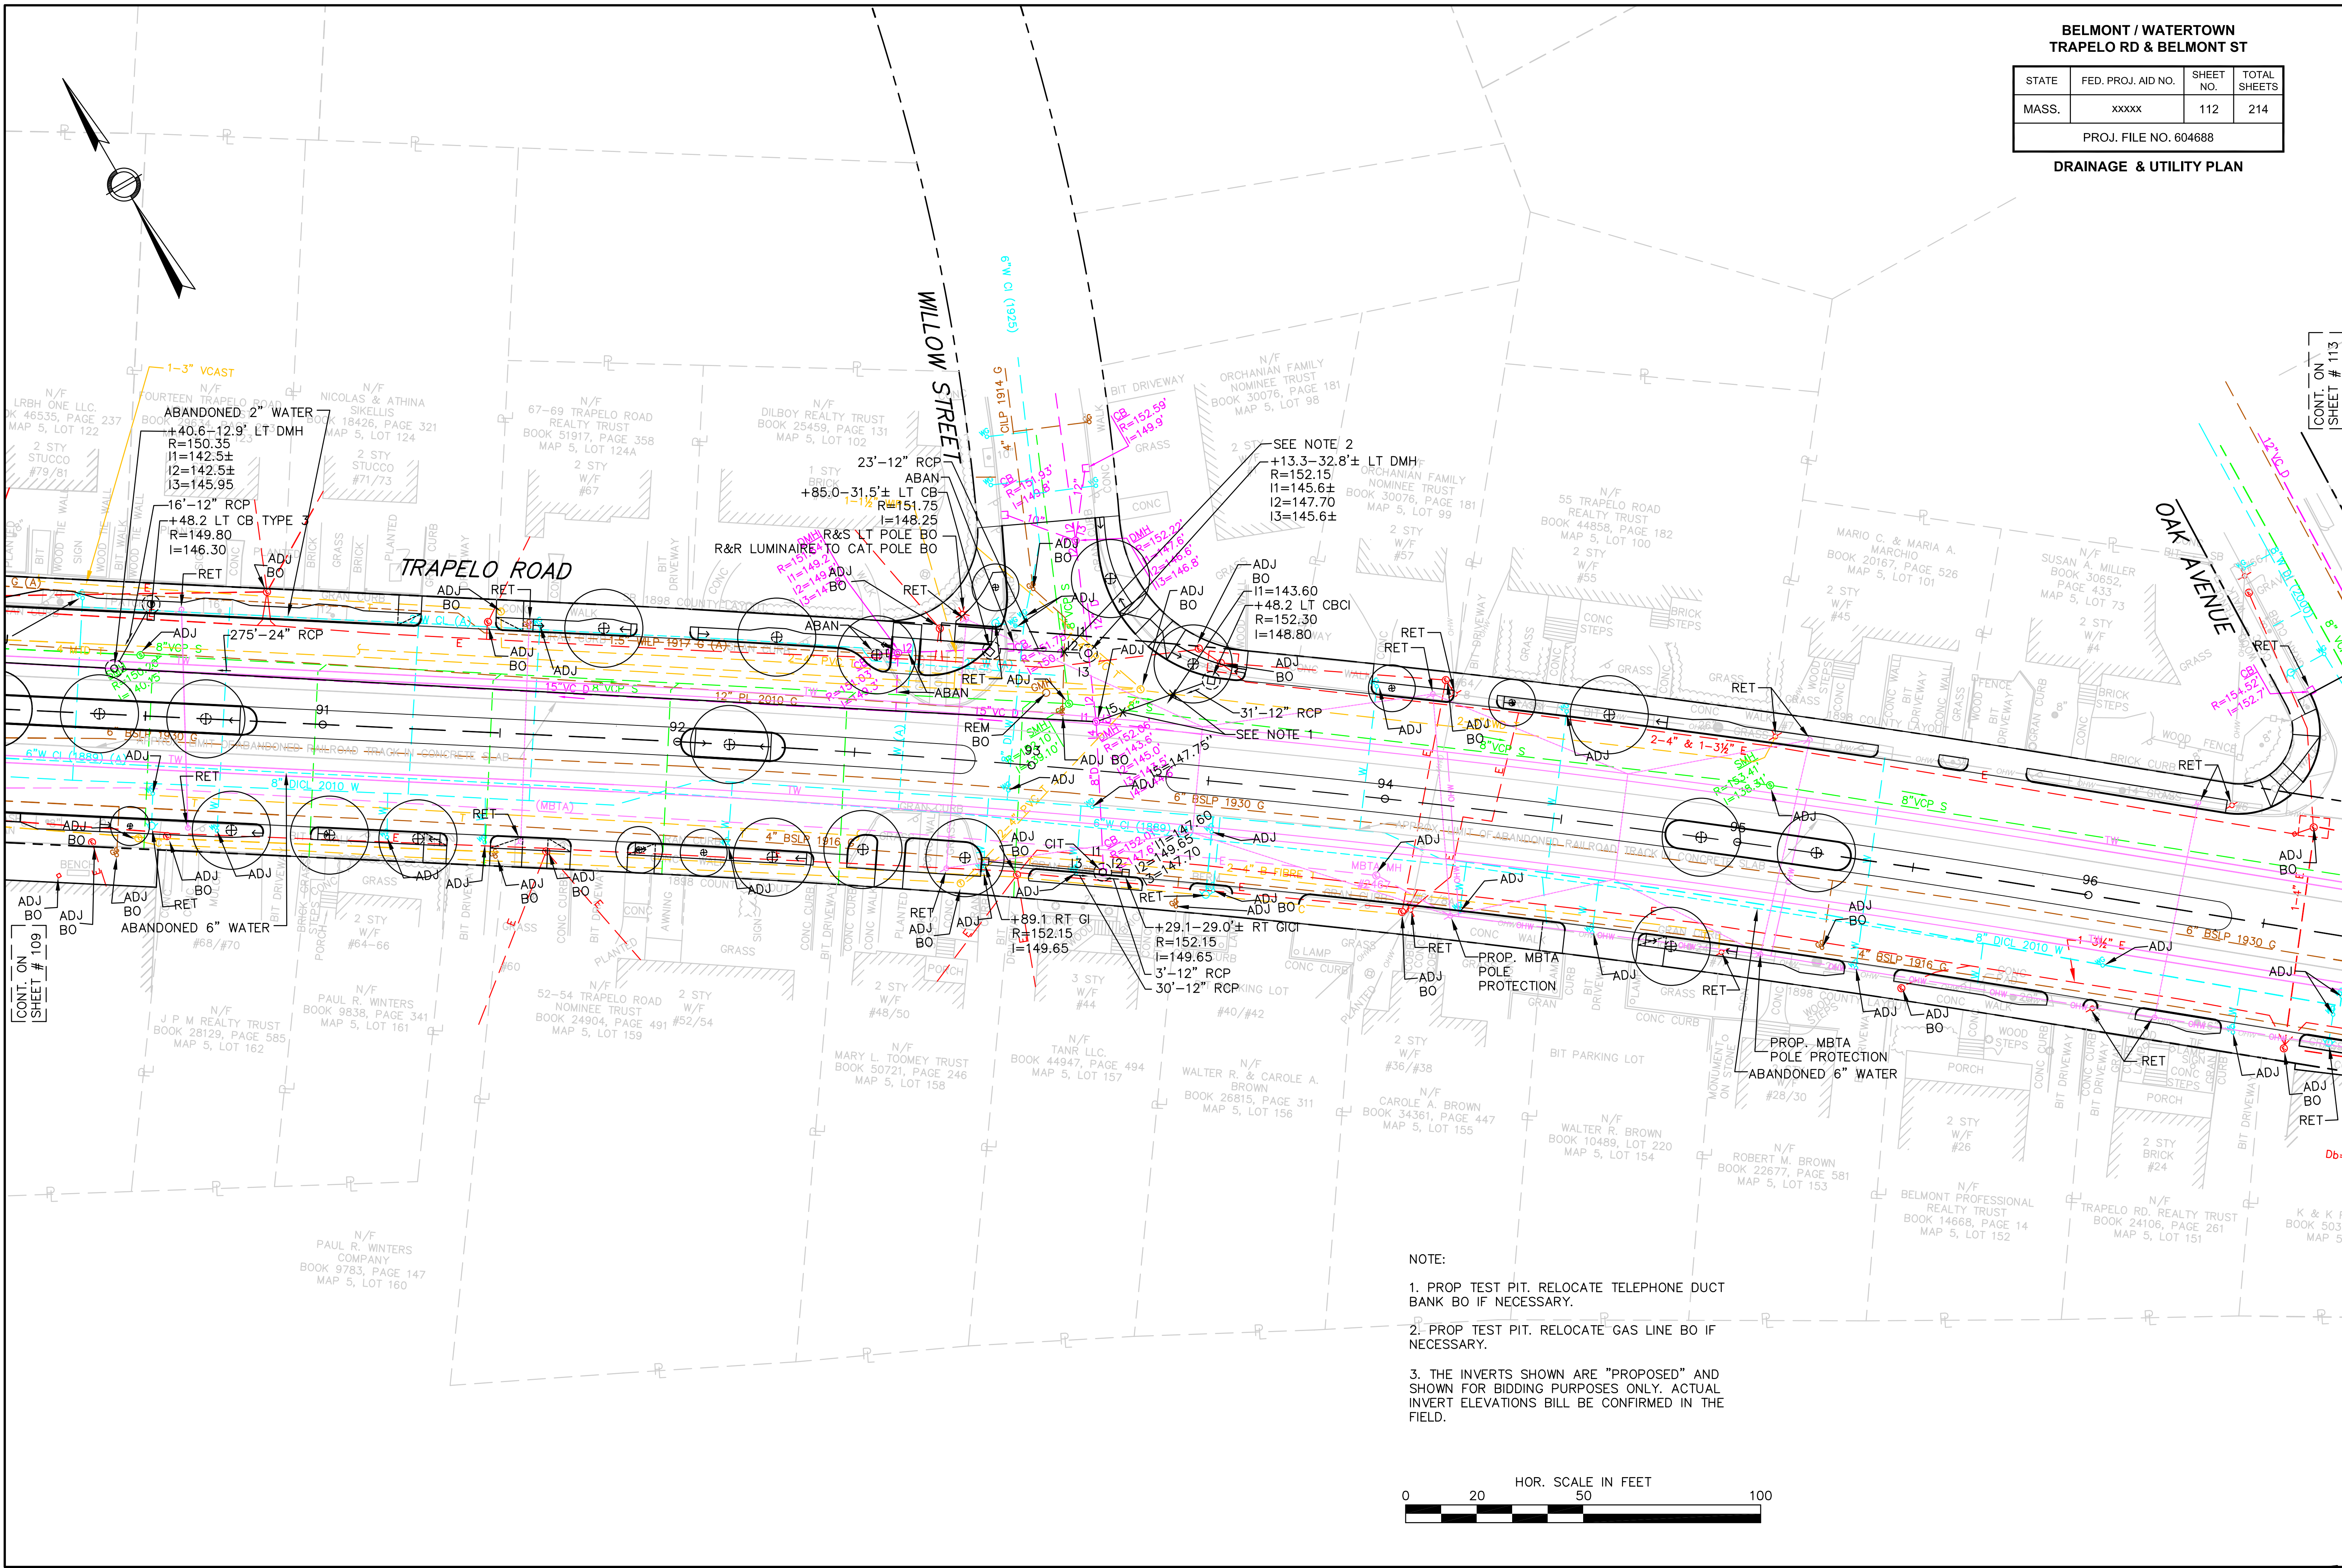

- NOTE:
1. PROP TEST PIT. RELOCATE TELEPHONE DUCT BANK BO IF NECESSARY.
 2. PROP TEST PIT. RELOCATE GAS LINE BO IF NECESSARY.
 3. THE INVERTS SHOWN ARE "PROPOSED" AND SHOWN FOR BIDDING PURPOSES ONLY. ACTUAL INVERT ELEVATIONS WILL BE CONFIRMED IN THE FIELD.

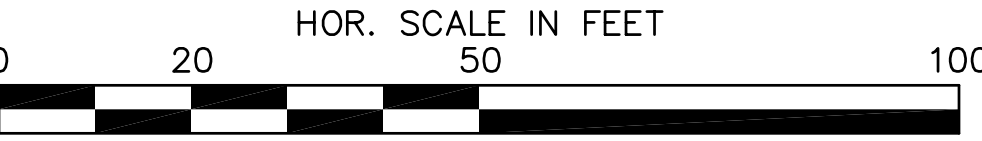


BELMONT / WATERTOWN
TRAPELO RD & BELMONT ST

STATE	FED. PROJ. AID NO.	SHEET NO.	TOTAL SHEETS
MASS.	XXXXX	113	214

PROJ. FILE NO. 604688

DRAINAGE & UTILITY PLAN

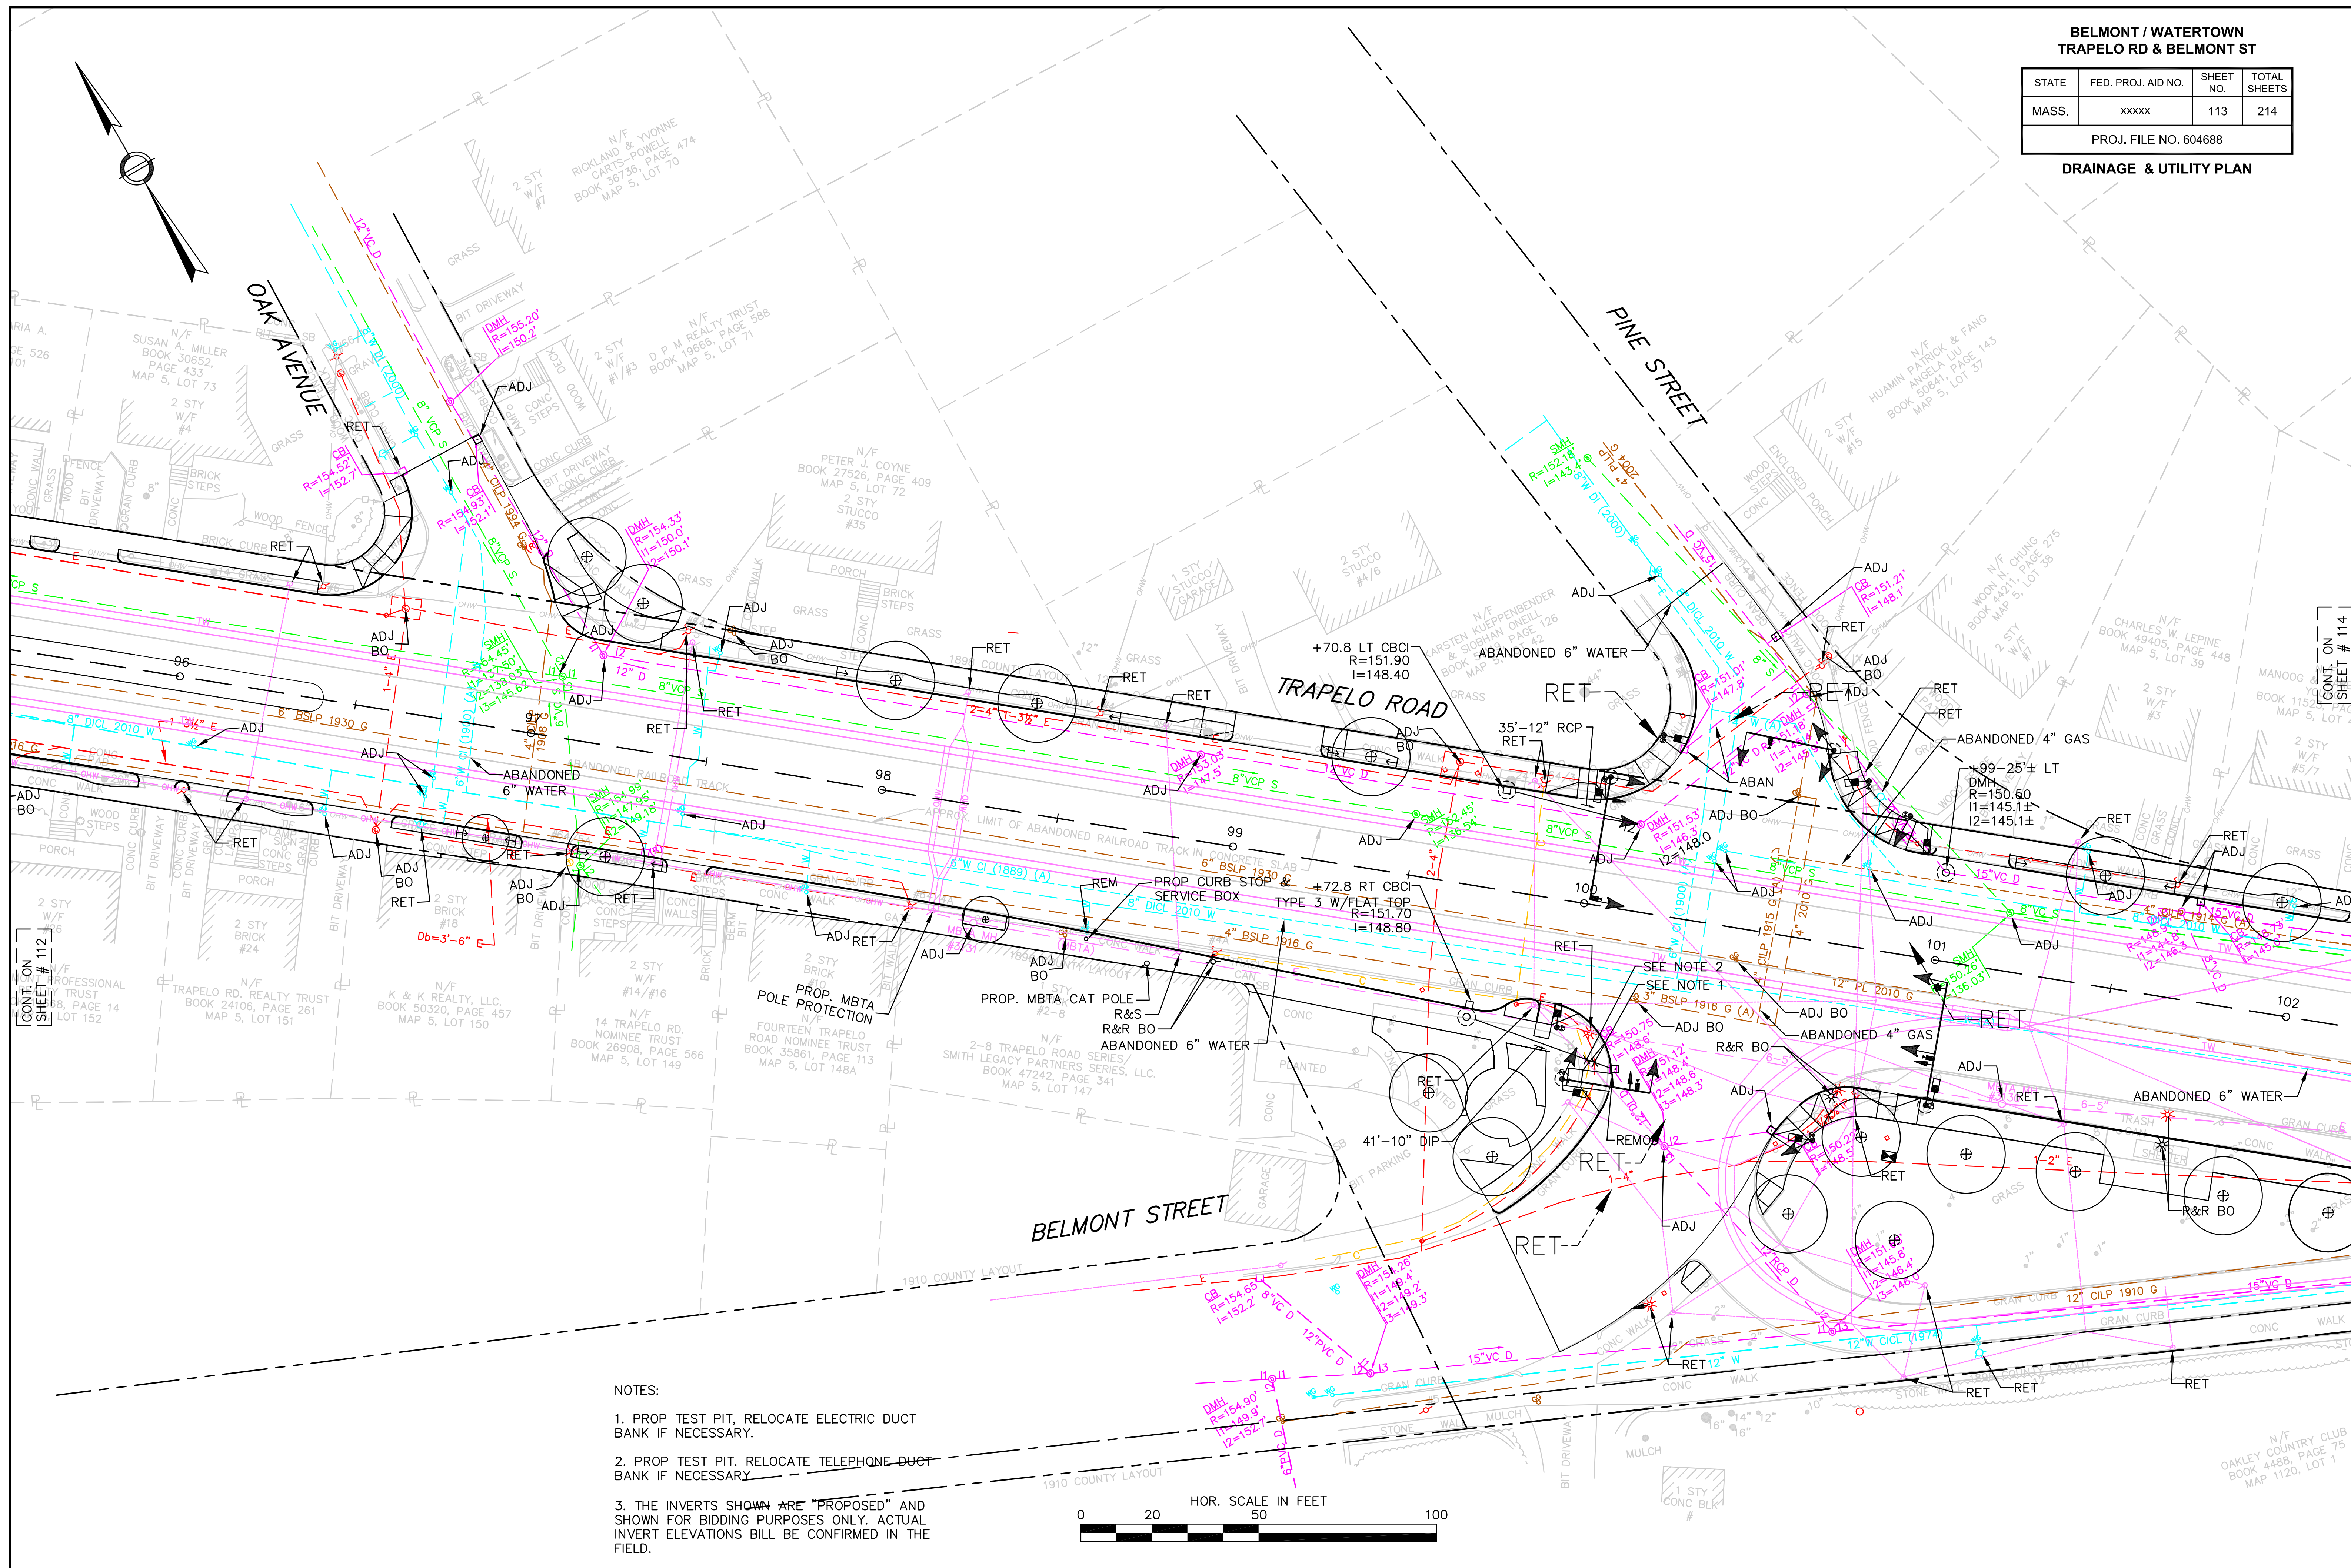


NOTES:

1. PROP TEST PIT, RELOCATE ELECTRIC DUCT BANK IF NECESSARY.
2. PROP TEST PIT, RELOCATE TELEPHONE DUCT BANK IF NECESSARY.
3. THE INVERTS SHOWN ARE "PROPOSED" AND SHOWN FOR BIDDING PURPOSES ONLY. ACTUAL INVERT ELEVATIONS WILL BE CONFIRMED IN THE FIELD.




STATE	FED. PROJ. AID NO.	SHEET NO.	TOTAL SHEETS
MASS.	xxxxxx	114	214

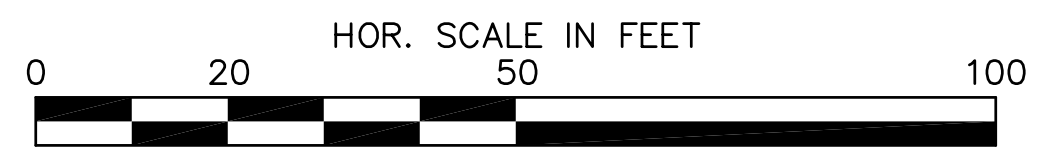


BELMONT / WATERTOWN
TRAPELO RD & BELMONT ST

STATE	FED. PROJ. AID NO.	SHEET NO.	TOTAL SHEETS
MASS.	XXXXX	115	214
PROJ. FILE NO. 604688			

DRAINAGE & UTILITY PLAN

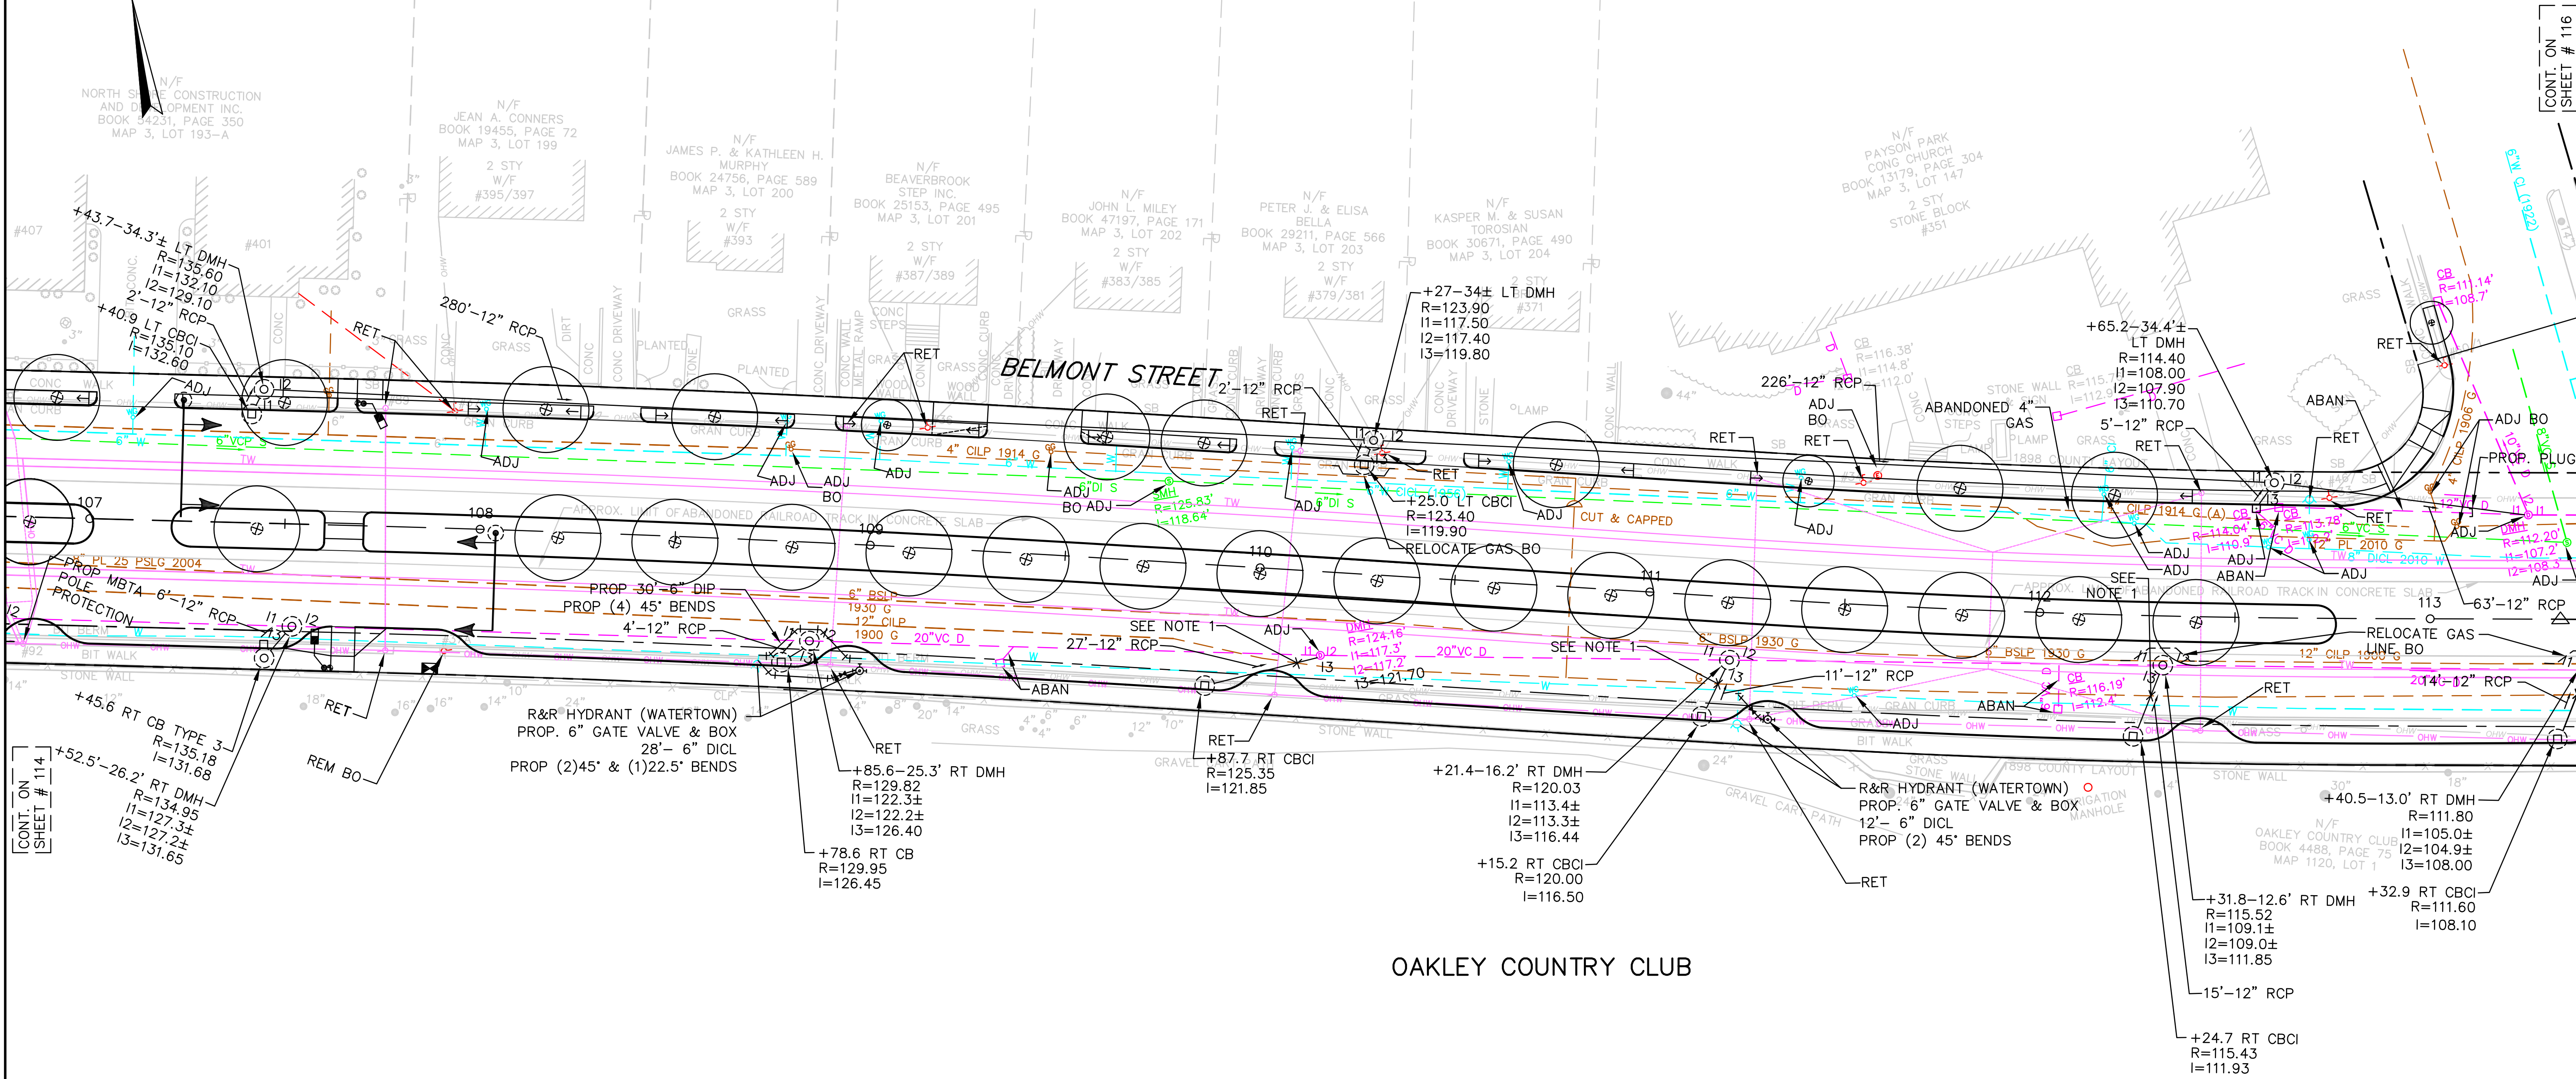

OAKLEY COUNTRY CLUB

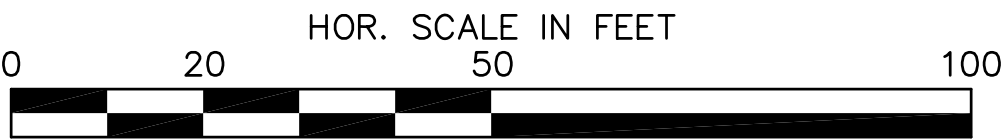


NOTE:

1. PROP TEST PIT. RELOCATE GAS LINE BO IF NECESSARY.
2. THE INVERTS SHOWN ARE "PROPOSED" AND SHOWN FOR BIDDING PURPOSES ONLY. ACTUAL INVERT ELEVATIONS WILL BE CONFIRMED IN THE FIELD.

STATE	FED. PROJ. AID NO.	SHEET NO.	TOTAL SHEETS
MASS.	xxxxx	116	214


DRAINAGE & UTILITY PLAN

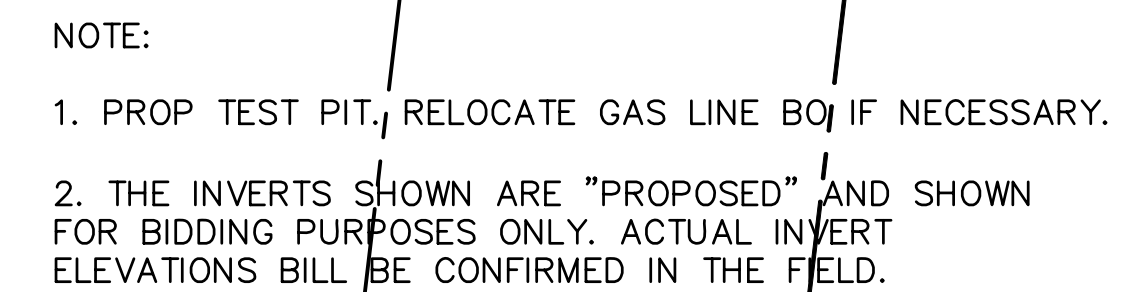

BELMONT / WATERTOWN TRAPELO RD & BELMONT ST

STATE	FED. PROJ. AID NO.	SHEET NO.	TOTAL SHEETS
MASS.	xxxxx	117	214
PROJ. FILE NO. 604688			

DRAINAGE & UTILITY PLAN

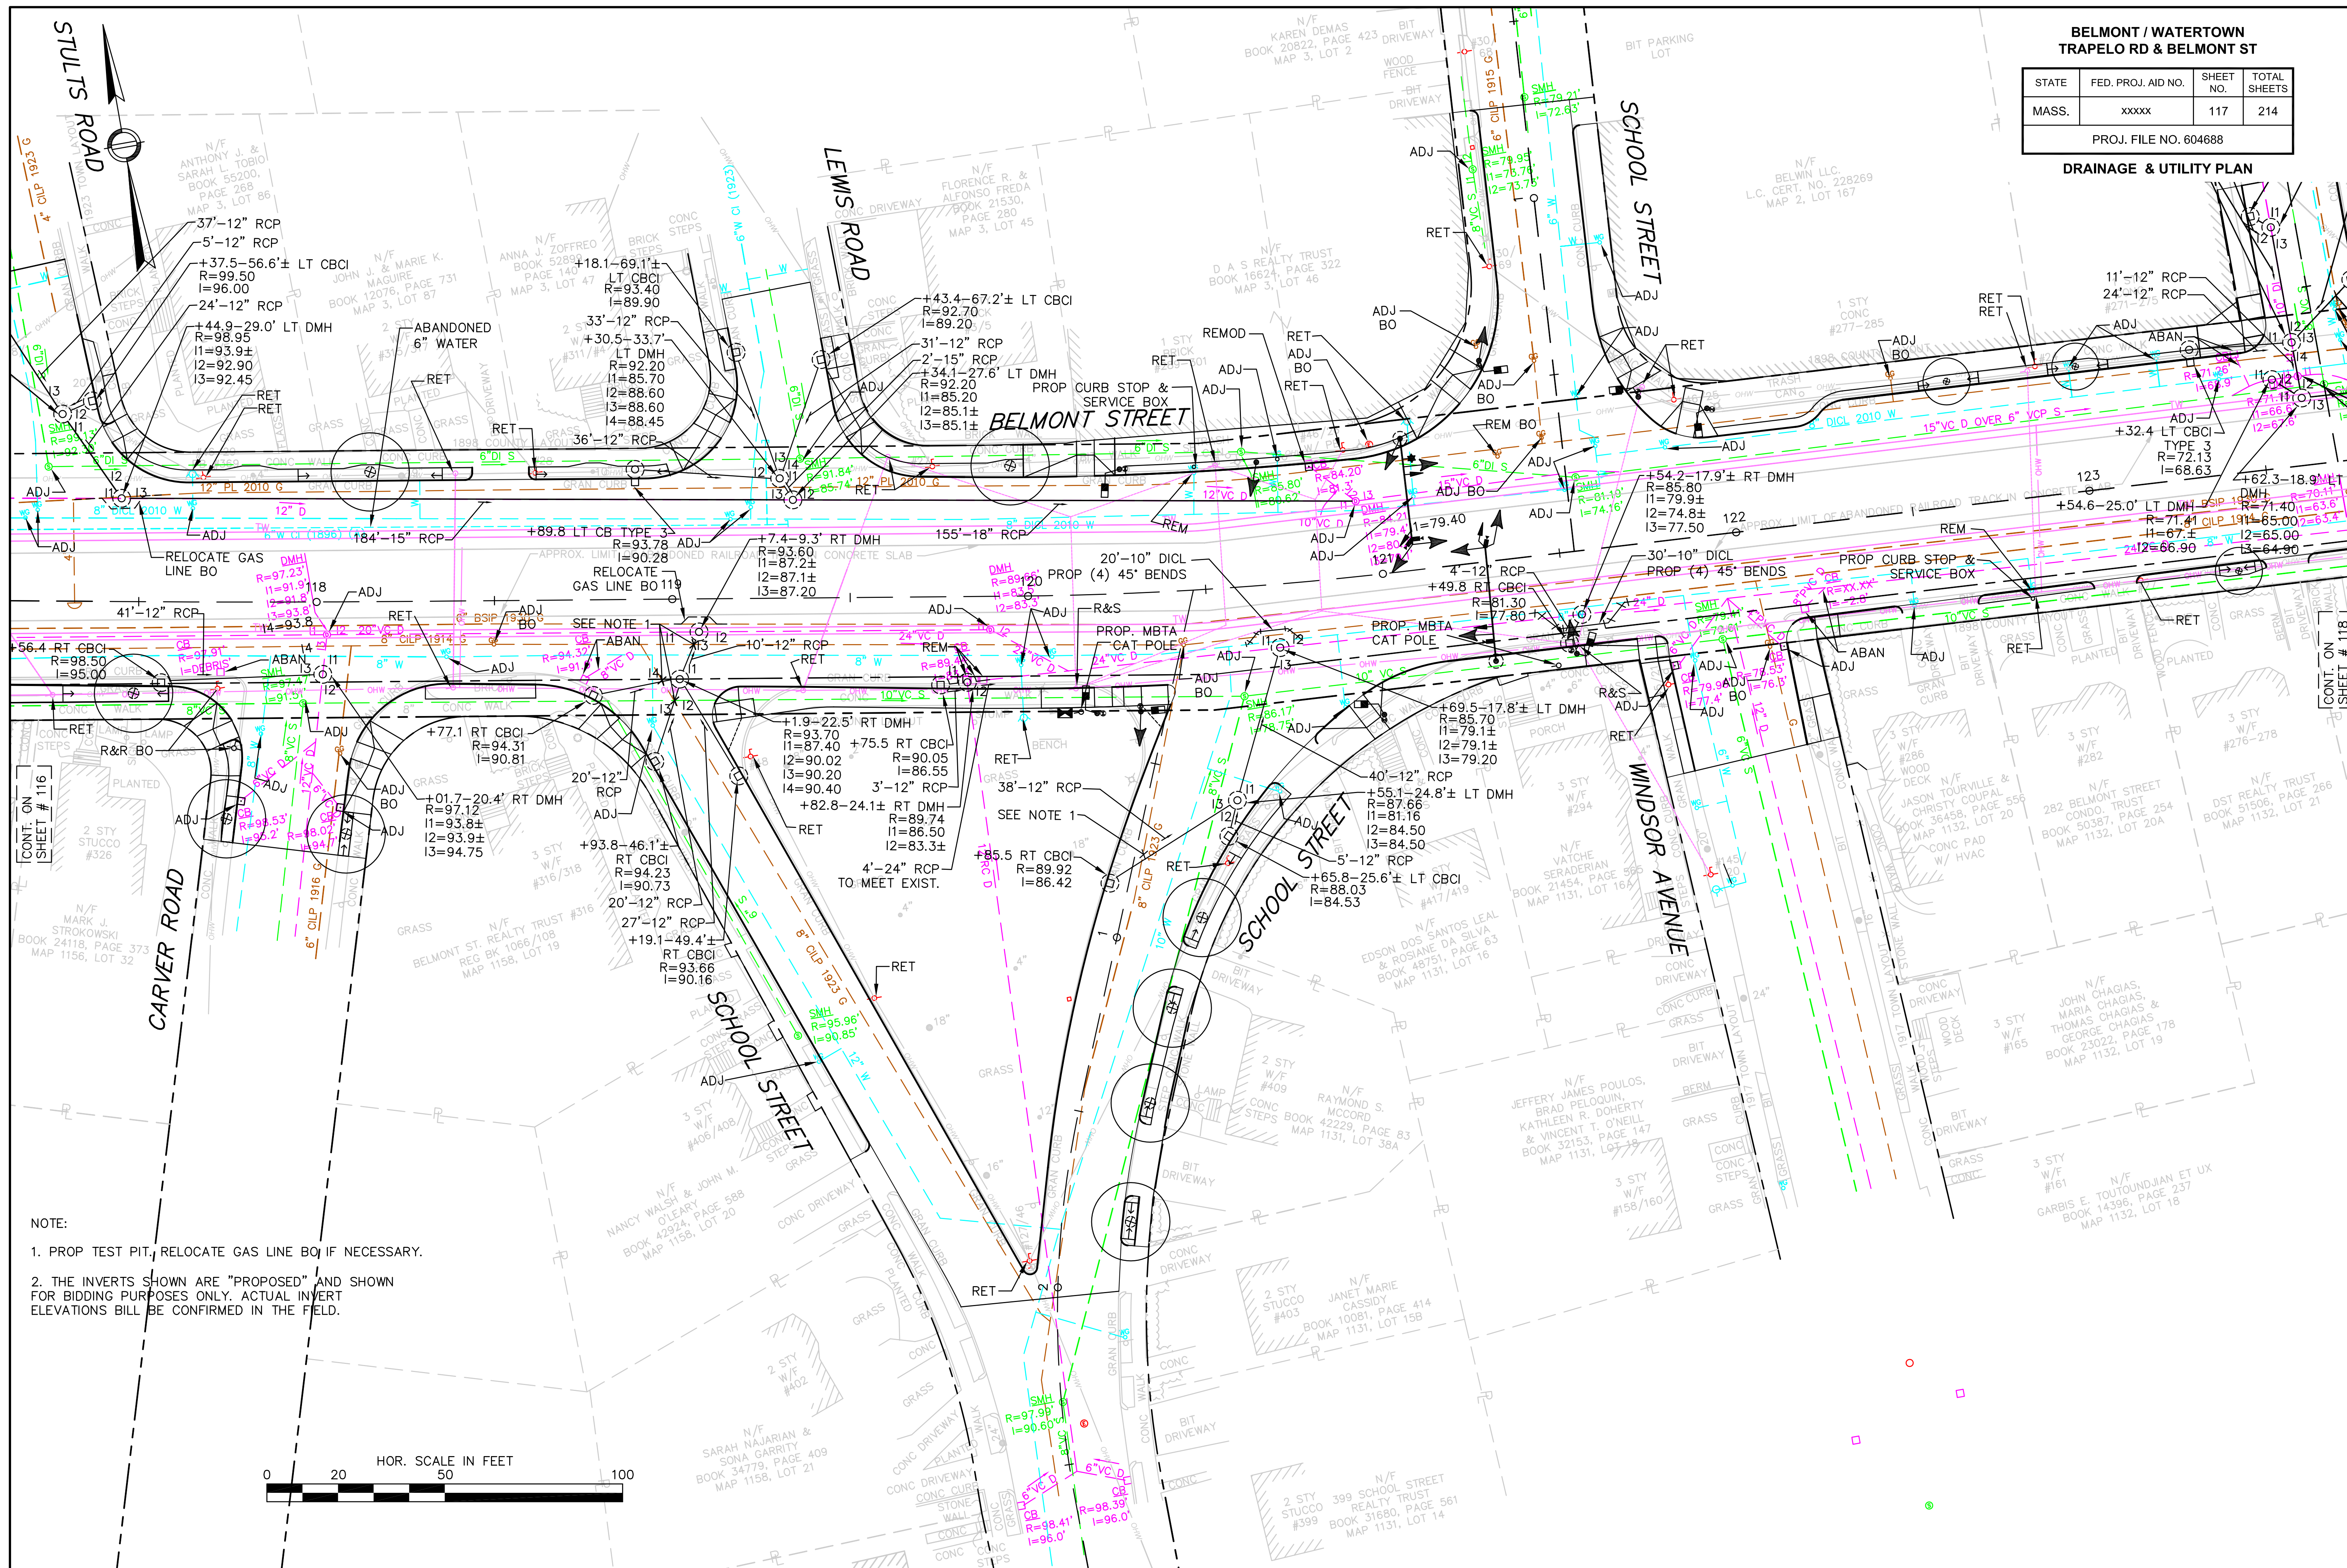

BELMONT / WATERTOWN
TRAPELO RD & BELMONT ST

STATE	FED. PROJ. AID NO.	SHEET NO.	TOTAL SHEETS
MASS.	XXXXX	118	214
PROJ. FILE NO. 604688			

DRAINAGE & UTILITY PLAN



NOTE:

1. PROP TEST PIT. RELOCATE GAS LINE BO IF NECESSARY.
2. THE INVERTS SHOWN ARE "PROPOSED" AND SHOWN FOR BIDDING PURPOSES ONLY. ACTUAL INVERT ELEVATIONS WILL BE CONFIRMED IN THE FIELD.

**BELMONT / WATERTOWN
TRAPELO RD & BELMONT ST**

STATE	FED. PROJ. AID NO.	SHEET NO.	TOTAL SHEETS
MASS.	xxxxx	119	214
PROJ. FILE NO. 604688			

DRAINAGE & UTILITY PLAN



NOTE:



1. PROP. TEST PIT. RELOCATE GAS LINE BO IF NECESSARY.
2. THE INVERTS SHOWN ARE "PROPOSED" AND SHOWN FOR BIDDING PURPOSES ONLY. ACTUAL INVERT ELEVATIONS WILL BE CONFIRMED IN THE FIELD.

BELMONT / WATERTOWN
TRAPELO RD & BELMONT ST

STATE	FED. PROJ. AID NO.	SHEET NO.	TOTAL SHEETS
MASS.	xxxxx	120	214

PROJ. FILE NO. 604688

DRAINAGE & UTILITY PLAN

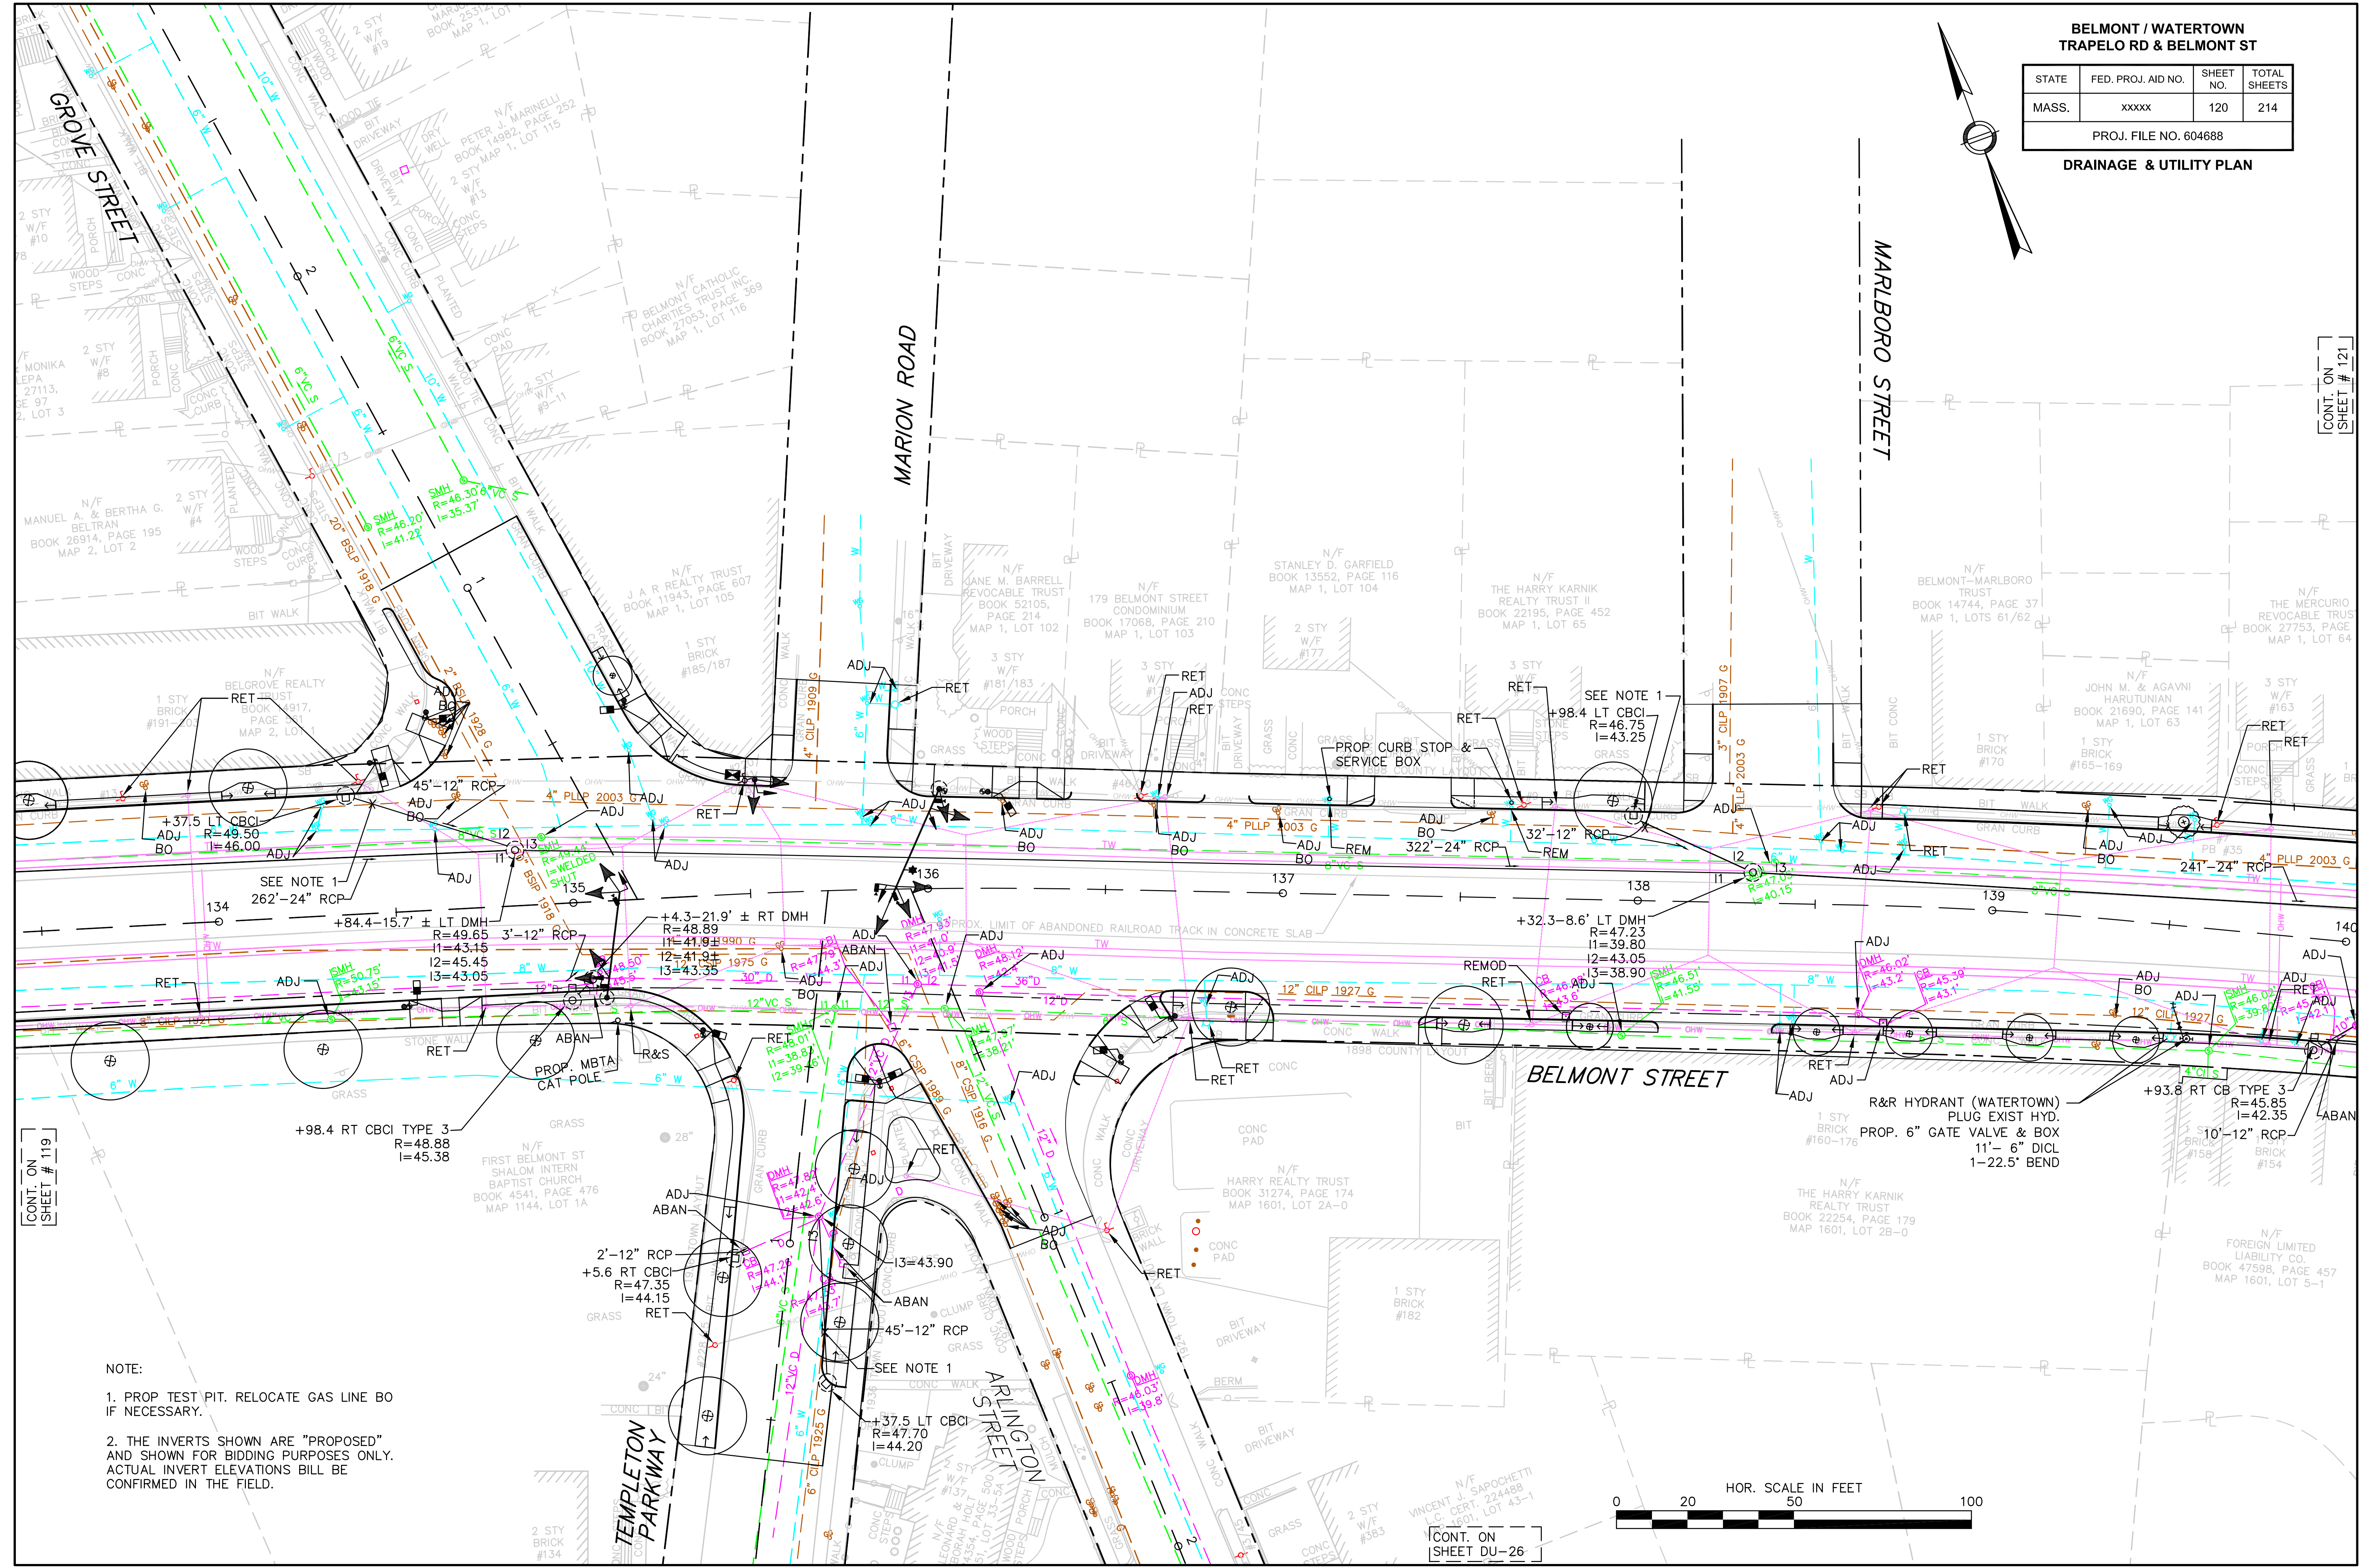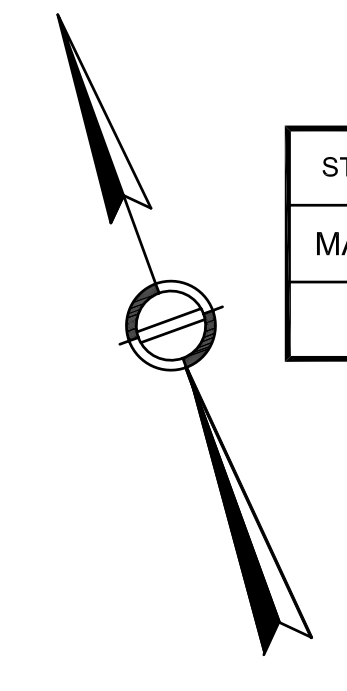

NOTE:

1. PROP TEST PIT. RELOCATE GAS LINE BO IF NECESSARY.
2. THE INVERTS SHOWN ARE "PROPOSED" AND SHOWN FOR BIDDING PURPOSES ONLY. ACTUAL INVERT ELEVATIONS WILL BE CONFIRMED IN THE FIELD.



CONT. ON
SHEET # 119

CONT. ON
SHEET # 121

CONT. ON
SHEET DU-26



**BELMONT / WATERTOWN
TRAPELO RD & BELMONT ST**

STATE	FED. PROJ. AID NO.	SHEET NO.	TOTAL SHEETS
MASS.	XXXXX	121	214
PROJ. FILE NO. 604688			

DRAINAGE & UTILITY PLAN


NOTE:

1. PROP TEST PIT. RELOCATE GAS LINE BO IF NECESSARY.
2. THE INVERTS SHOWN ARE "PROPOSED" AND SHOWN FOR BIDDING PURPOSES ONLY. ACTUAL INVERT ELEVATIONS WILL BE CONFIRMED IN THE FIELD.

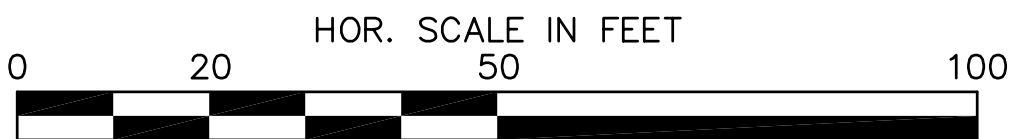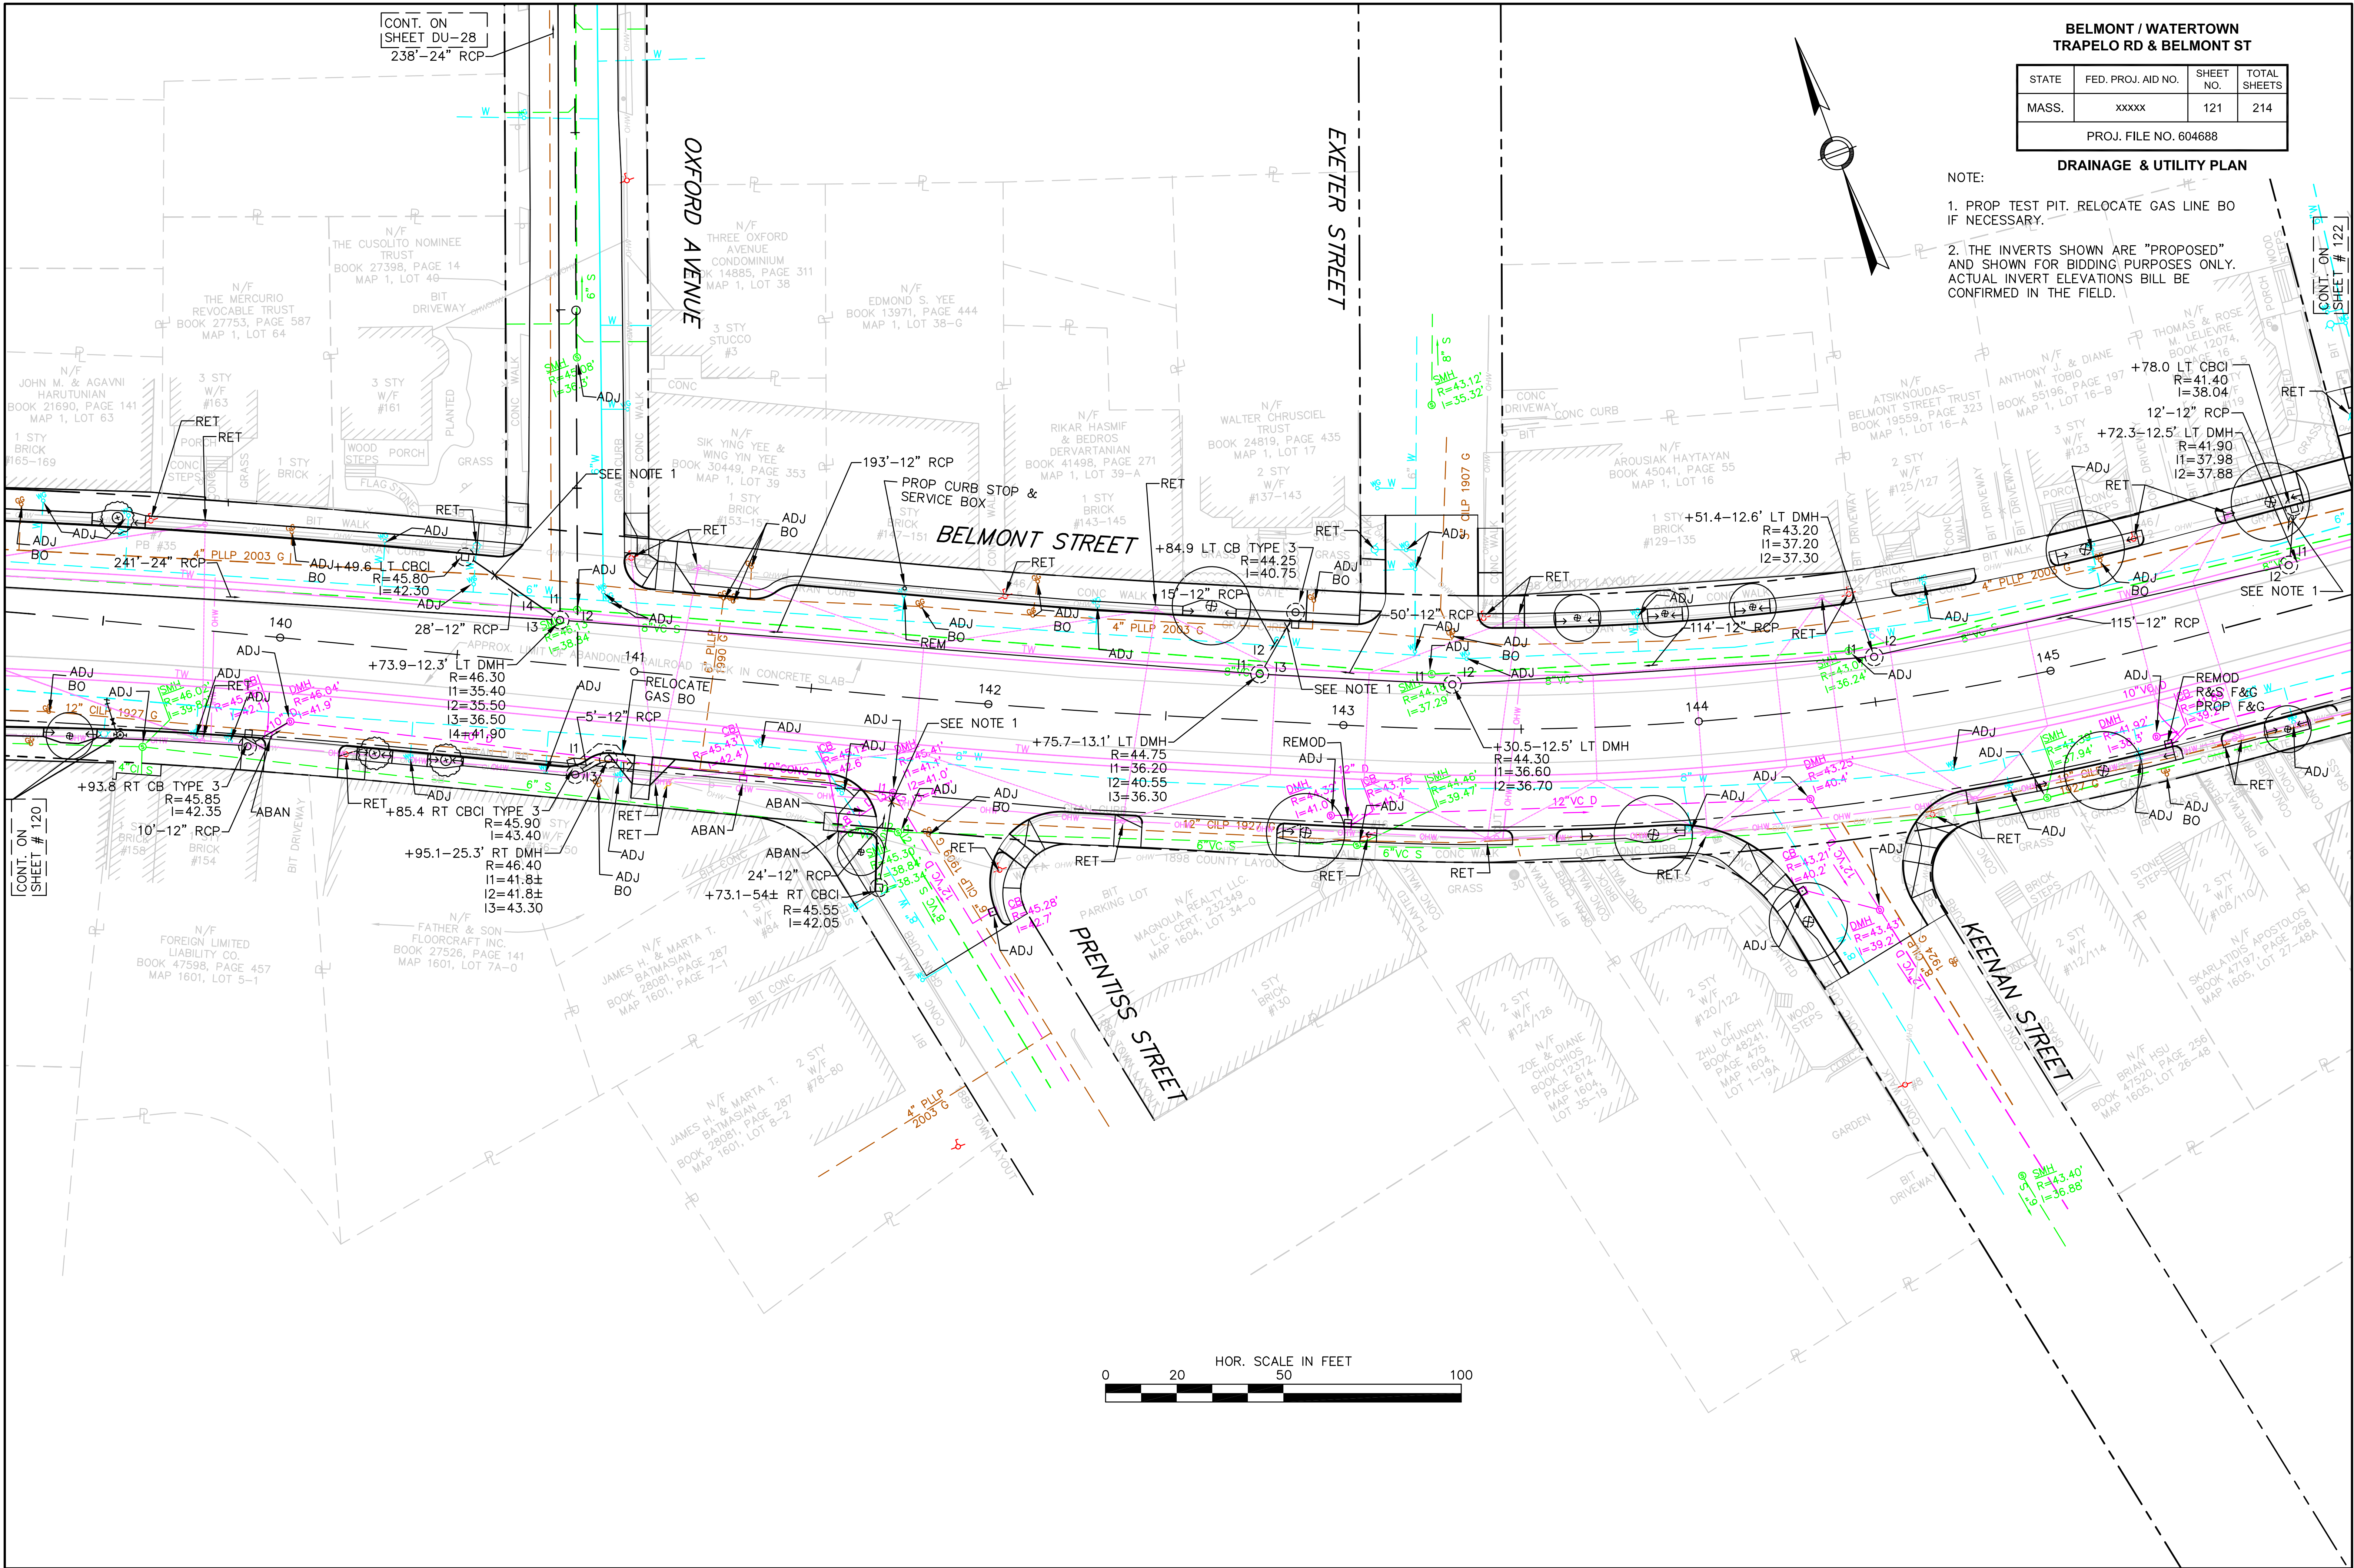

CONT. ON
SHEET # 121


- NOTE:
1. PROP TEST PIT. RELOCATE GAS LINE BO IF NECESSARY.
 2. THE INVERTS SHOWN ARE "PROPOSED" AND SHOWN FOR BIDDING PURPOSES ONLY. ACTUAL INVERT ELEVATIONS WILL BE CONFIRMED IN THE FIELD.

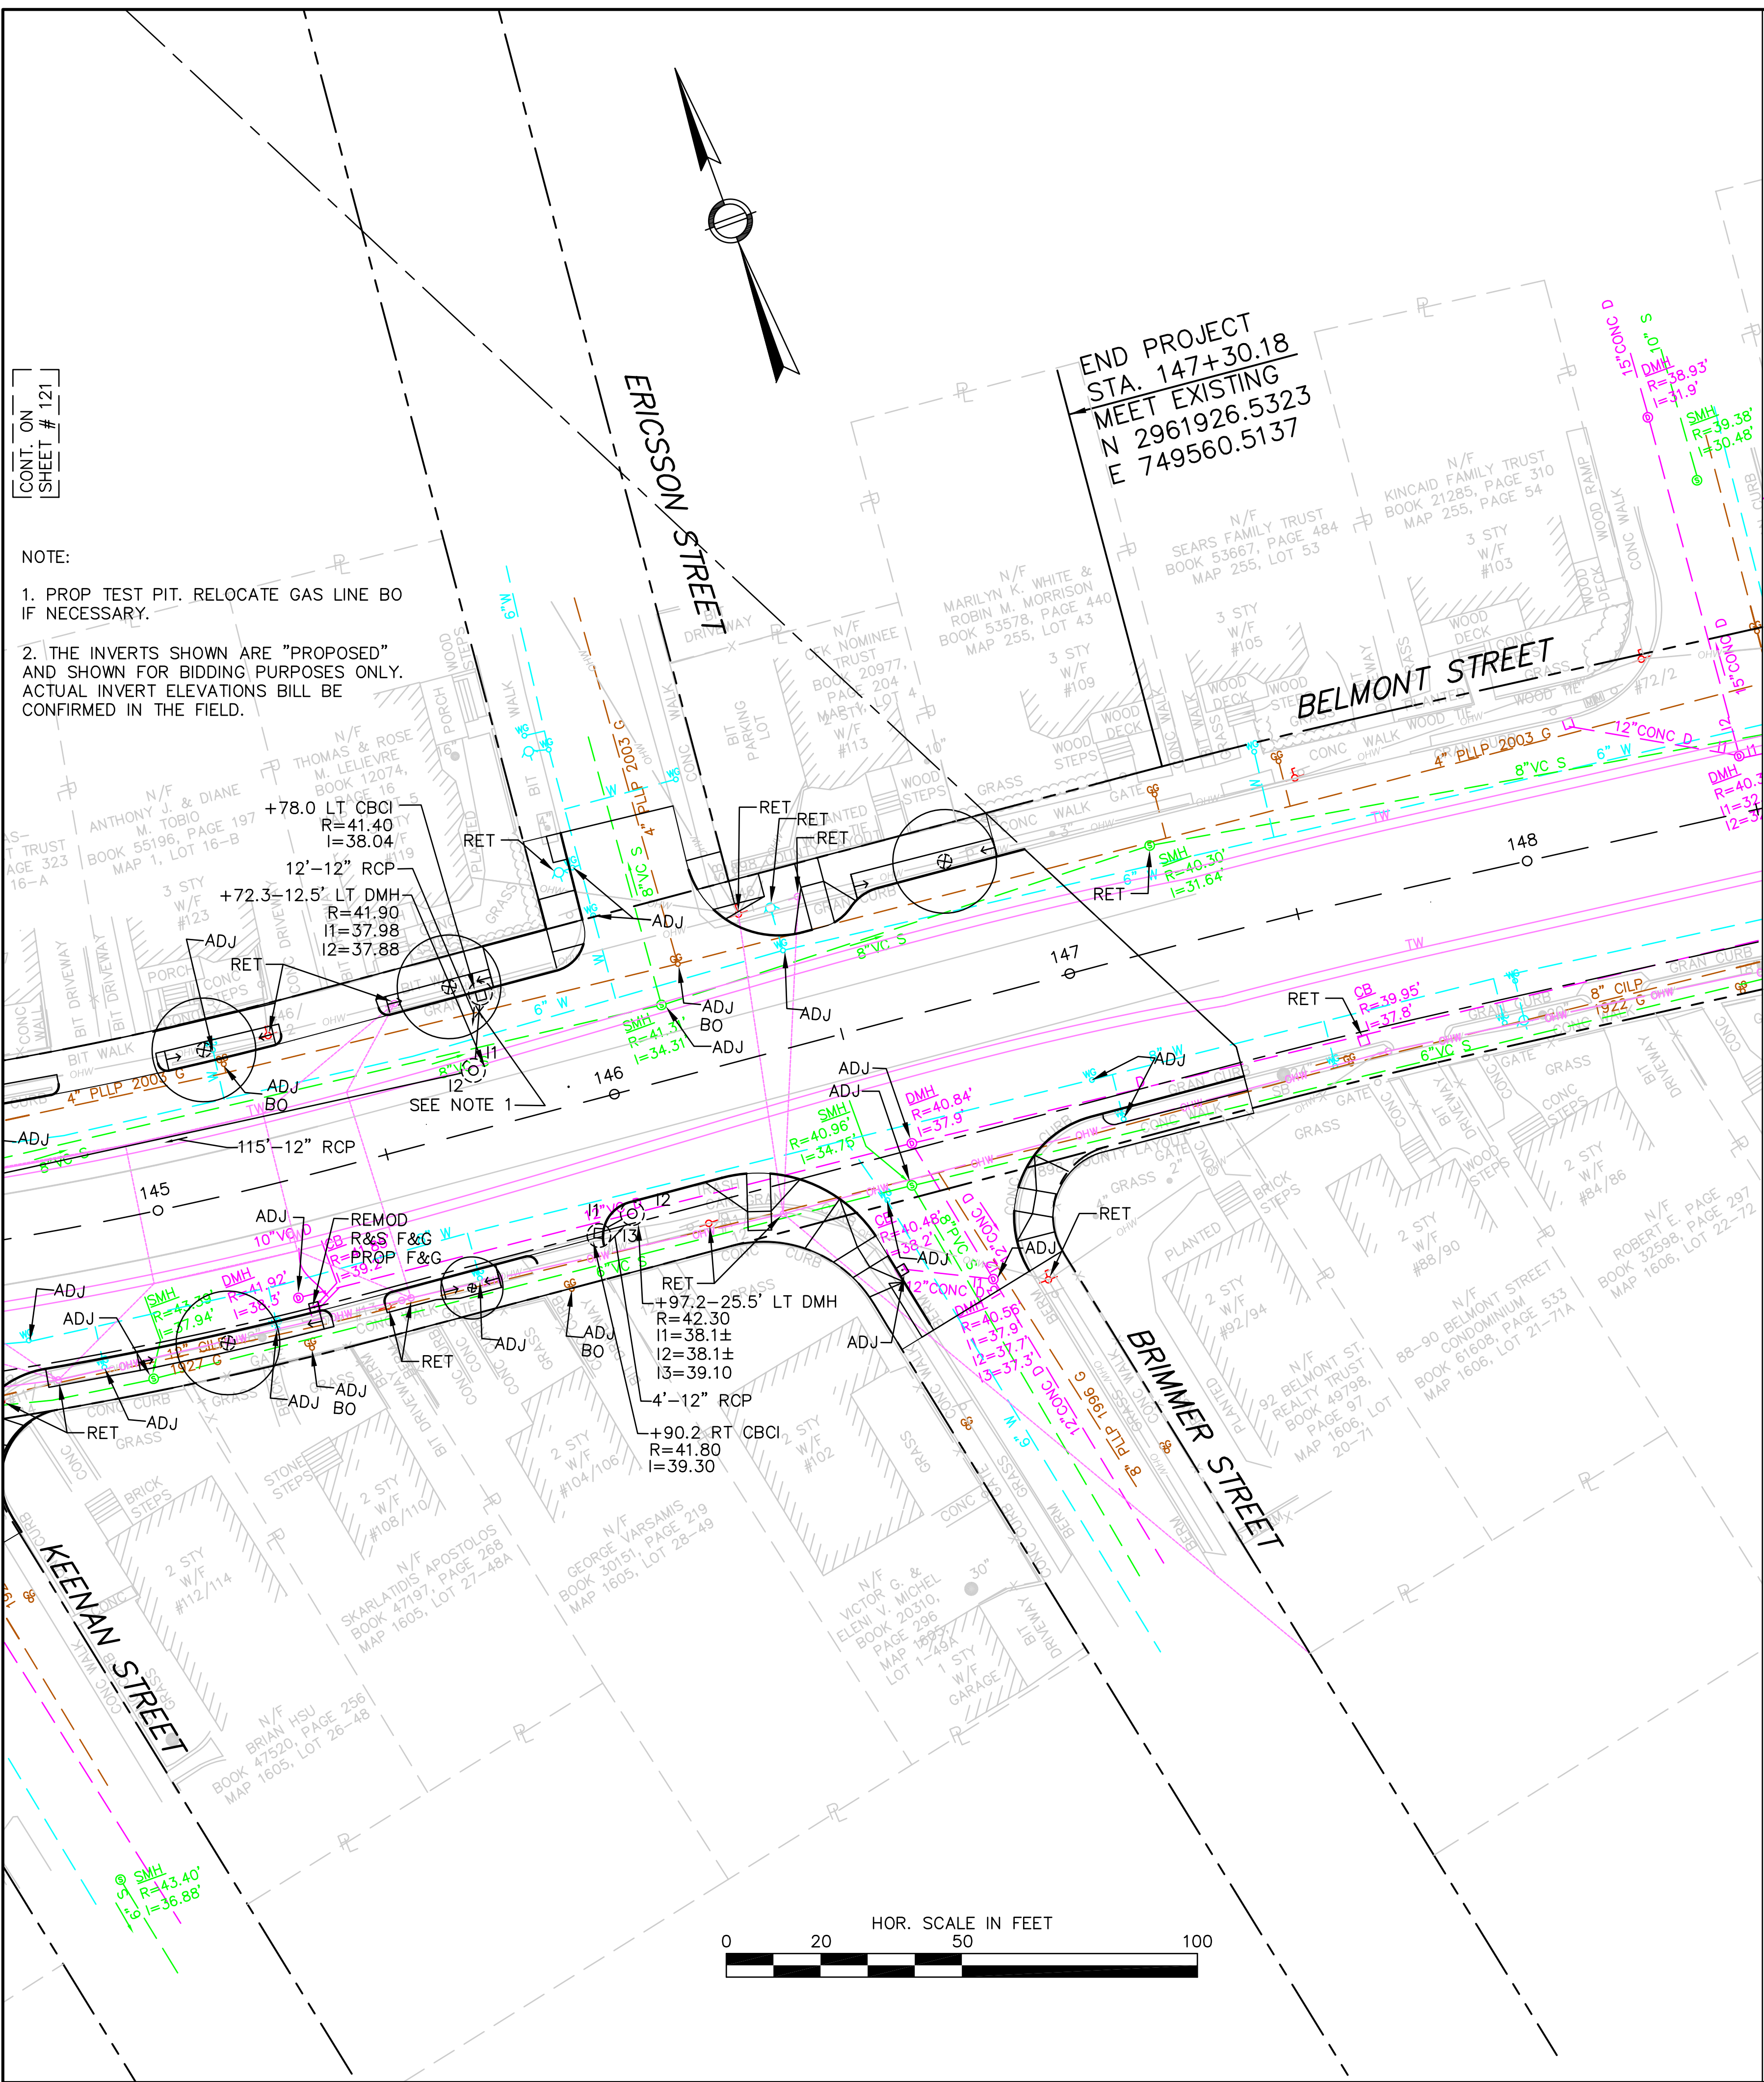

BELMONT / WATERTOWN
TRAPELO RD & BELMONT ST

STATE	FED. PROJ. AID NO.	SHEET NO.	TOTAL SHEETS
MASS.	xxxxx	122	214
PROJ. FILE NO. 604688			

DRAINAGE & UTILITY PLAN

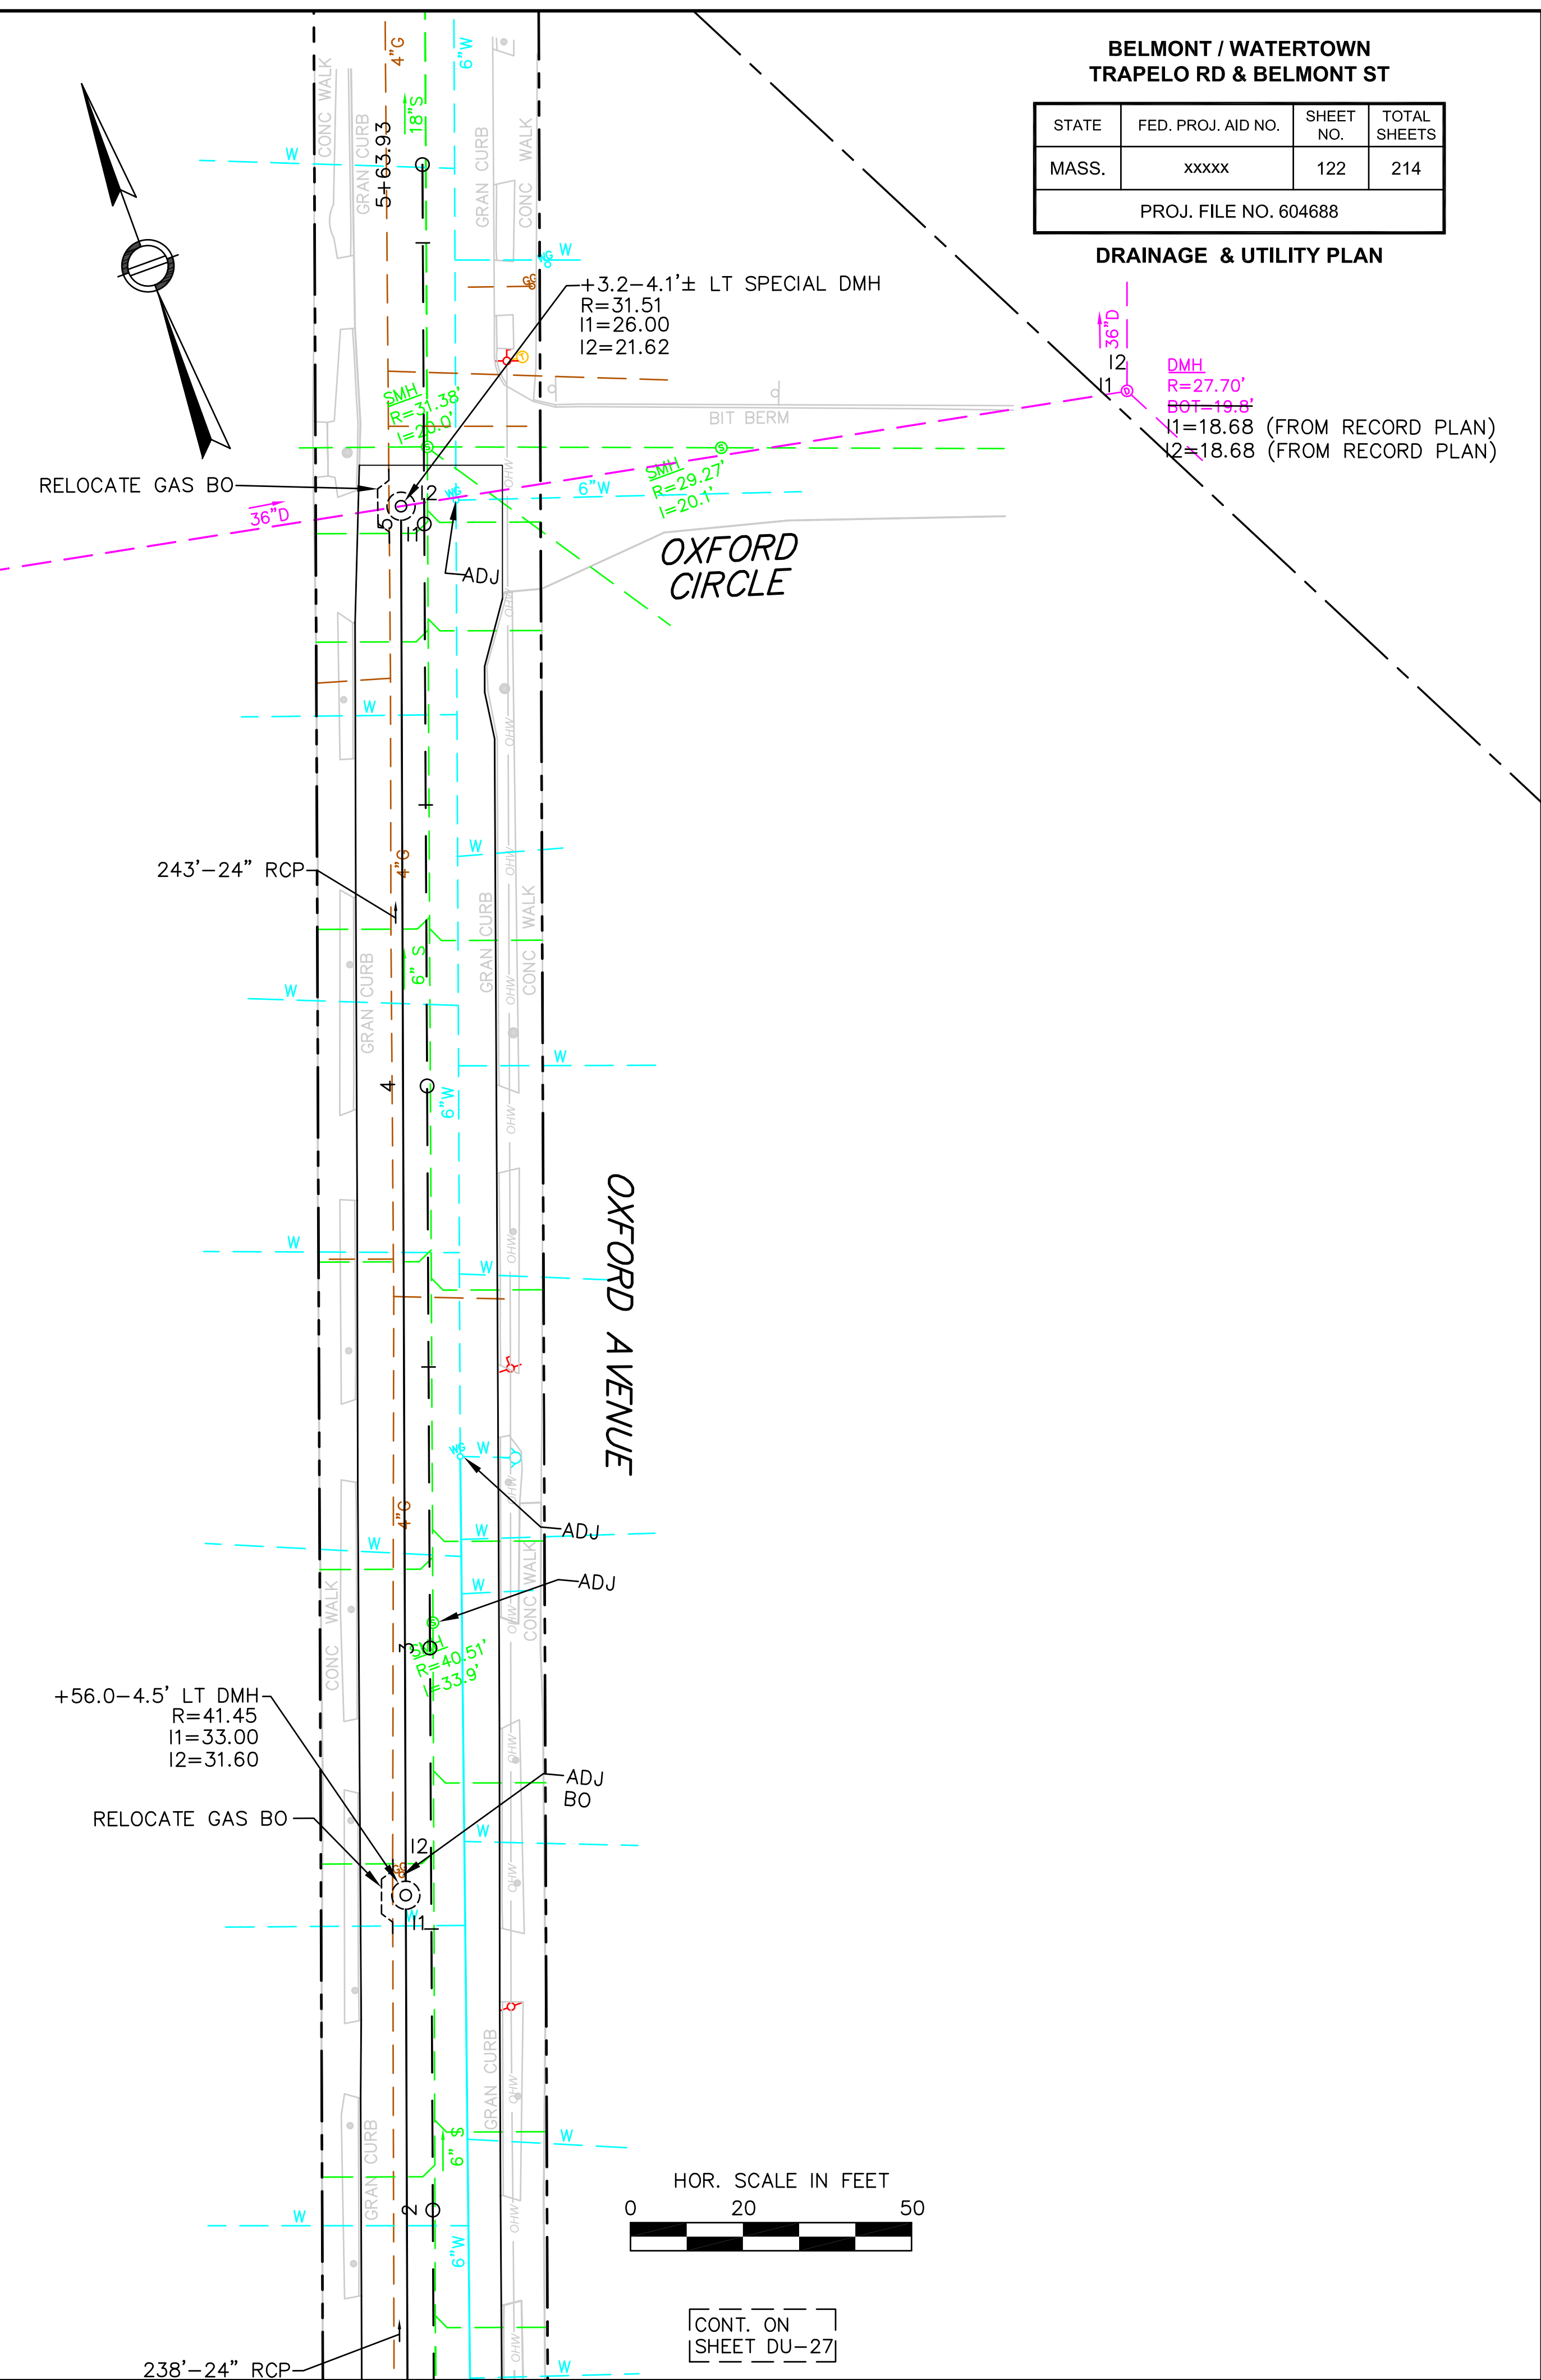

CONT. ON
SHEET DU-27